


 

 



 



LIGHTING SCHEDULE				
SYMBOL	FIXTURE	MANUFACTURER	SPECS	NOTES
	2X2 FIXTURE	TBD		CENTERED IN A.C.T
	DOWNLIGHT CAN	TBD	3" RADIUS	
	PENDANT FIXTURE	TBD	4 1/2" RADIUS	
	CHANDELIER FIXTURE	TBD	1'-0" RADIUS	
	LINEAR PENDANT	TBD	W: 6" L:1'-6"	

1 LIGHTING SCHEDULE
1/4" = 1'-0"

ELECTRICAL SYMBOL SCHEDULE			
SYMBOL	TYPE	MANUFACT.	NOTES
	DUPLEX OUTLET	TBD	1'-6" AFF
	FLOOR MOUNTED DUPLEX	TBD	FLOOR MOUNTED
	FLOOR MOUNTED J BOX	TBD	FLOOR MOUNTED
	DATA OUTLET	TBD	FLOOR MOUNTED
	WALL MOUNTED J BOX	TBD	1'-6" AFF
	WALL MOUNTED TV OUTLET	TBD	1'-6" AFF

2 P&T SCHEDULE
1/4" = 1'-0"


General Notes

No.	Revision/Issue	Date

Firm Name and Address
Rachel Skala

Project Name and Address
Studio Lobby

Project	Sheet
Date	A0.1
Scale	

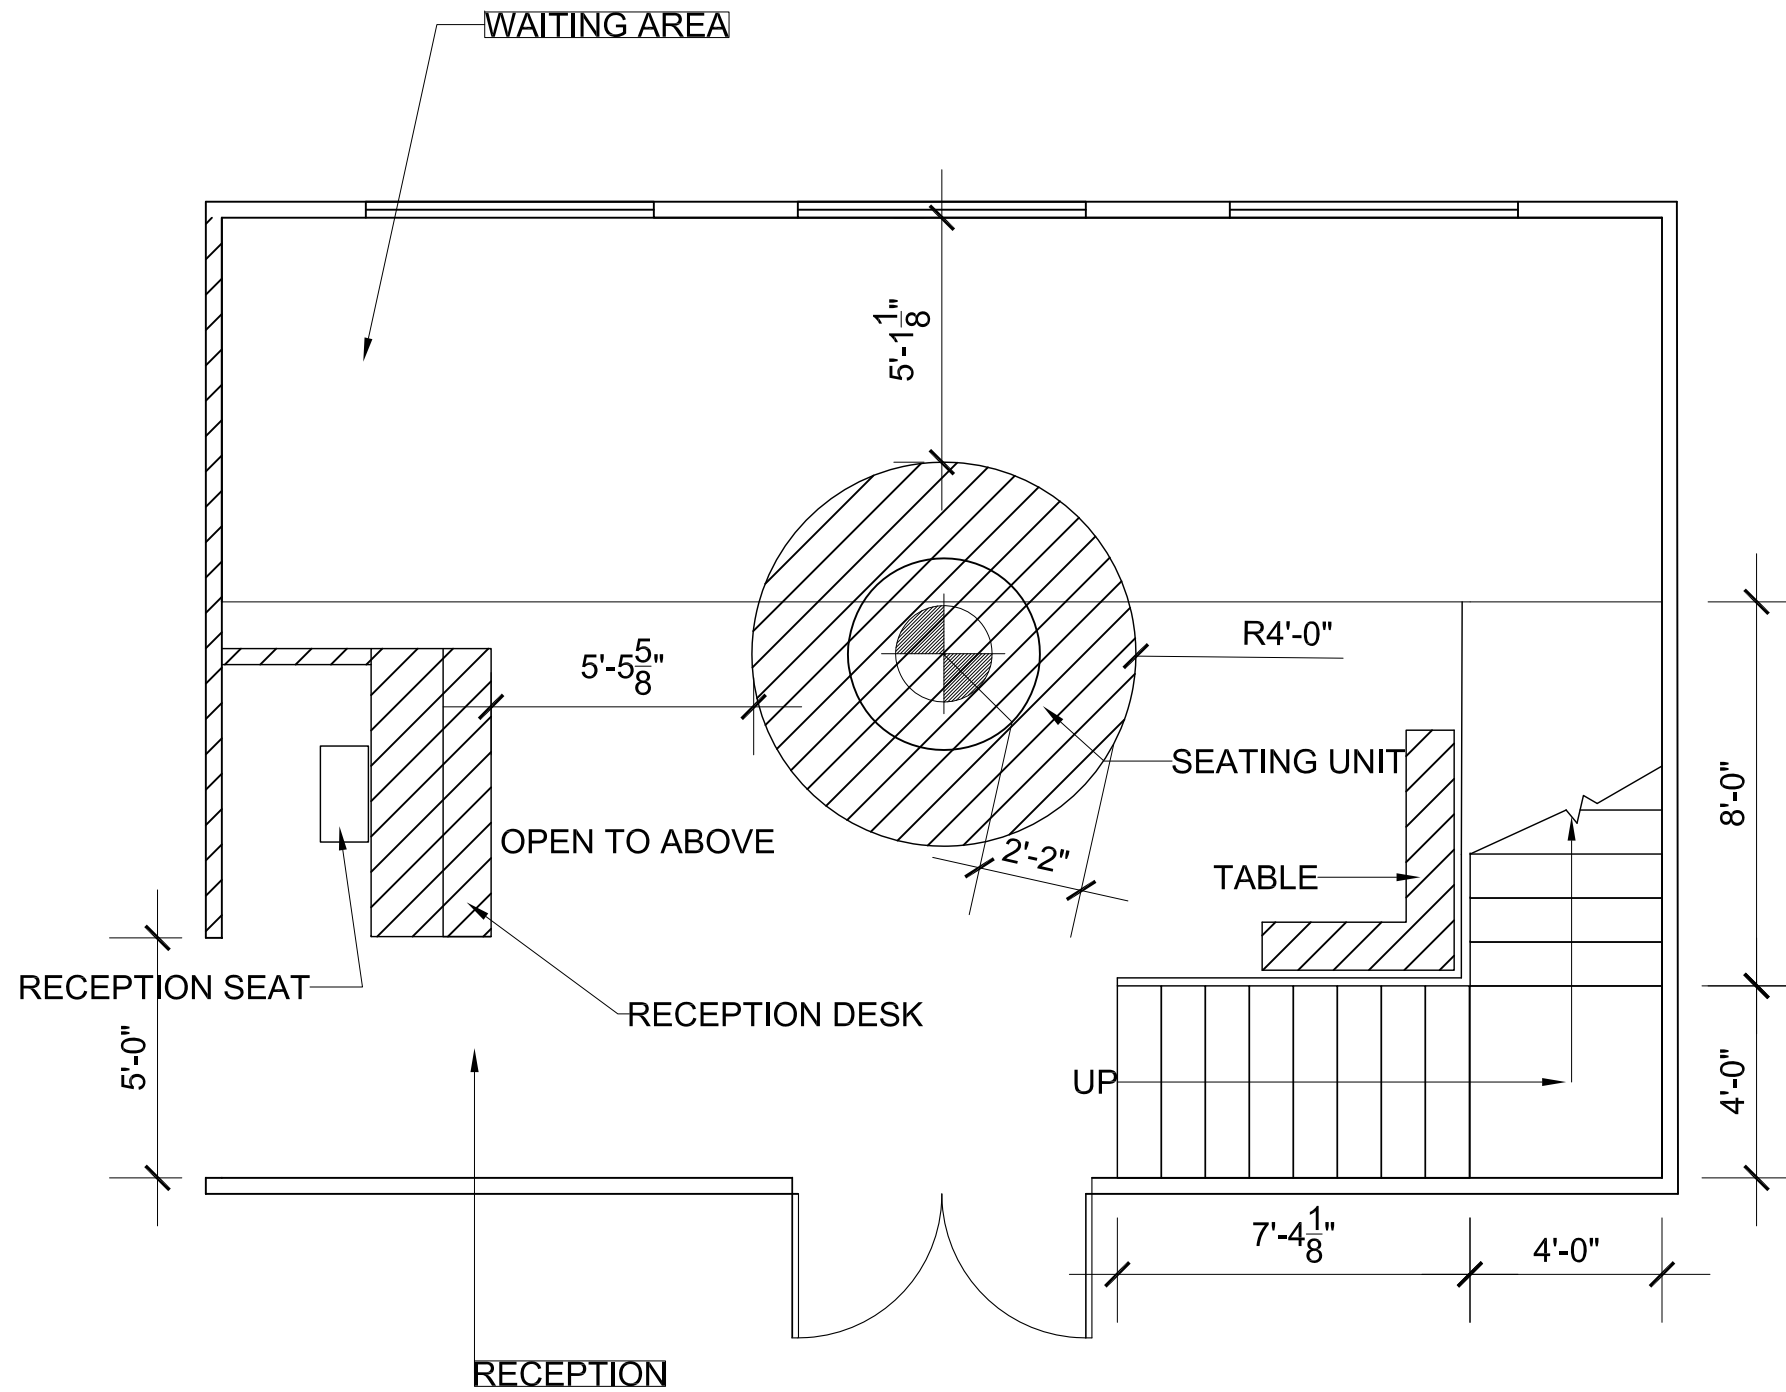

1 PARTITION PLAN - FIRST FLOOR
 $\frac{1}{4}'' = 1'-0''$

General Notes

No.	Revision/Issue	Date


Firm Name and Address

Rachel Skala

Project Name and Address

Studio Lobby

Project	Sheet
Date	A1.1
Scale	

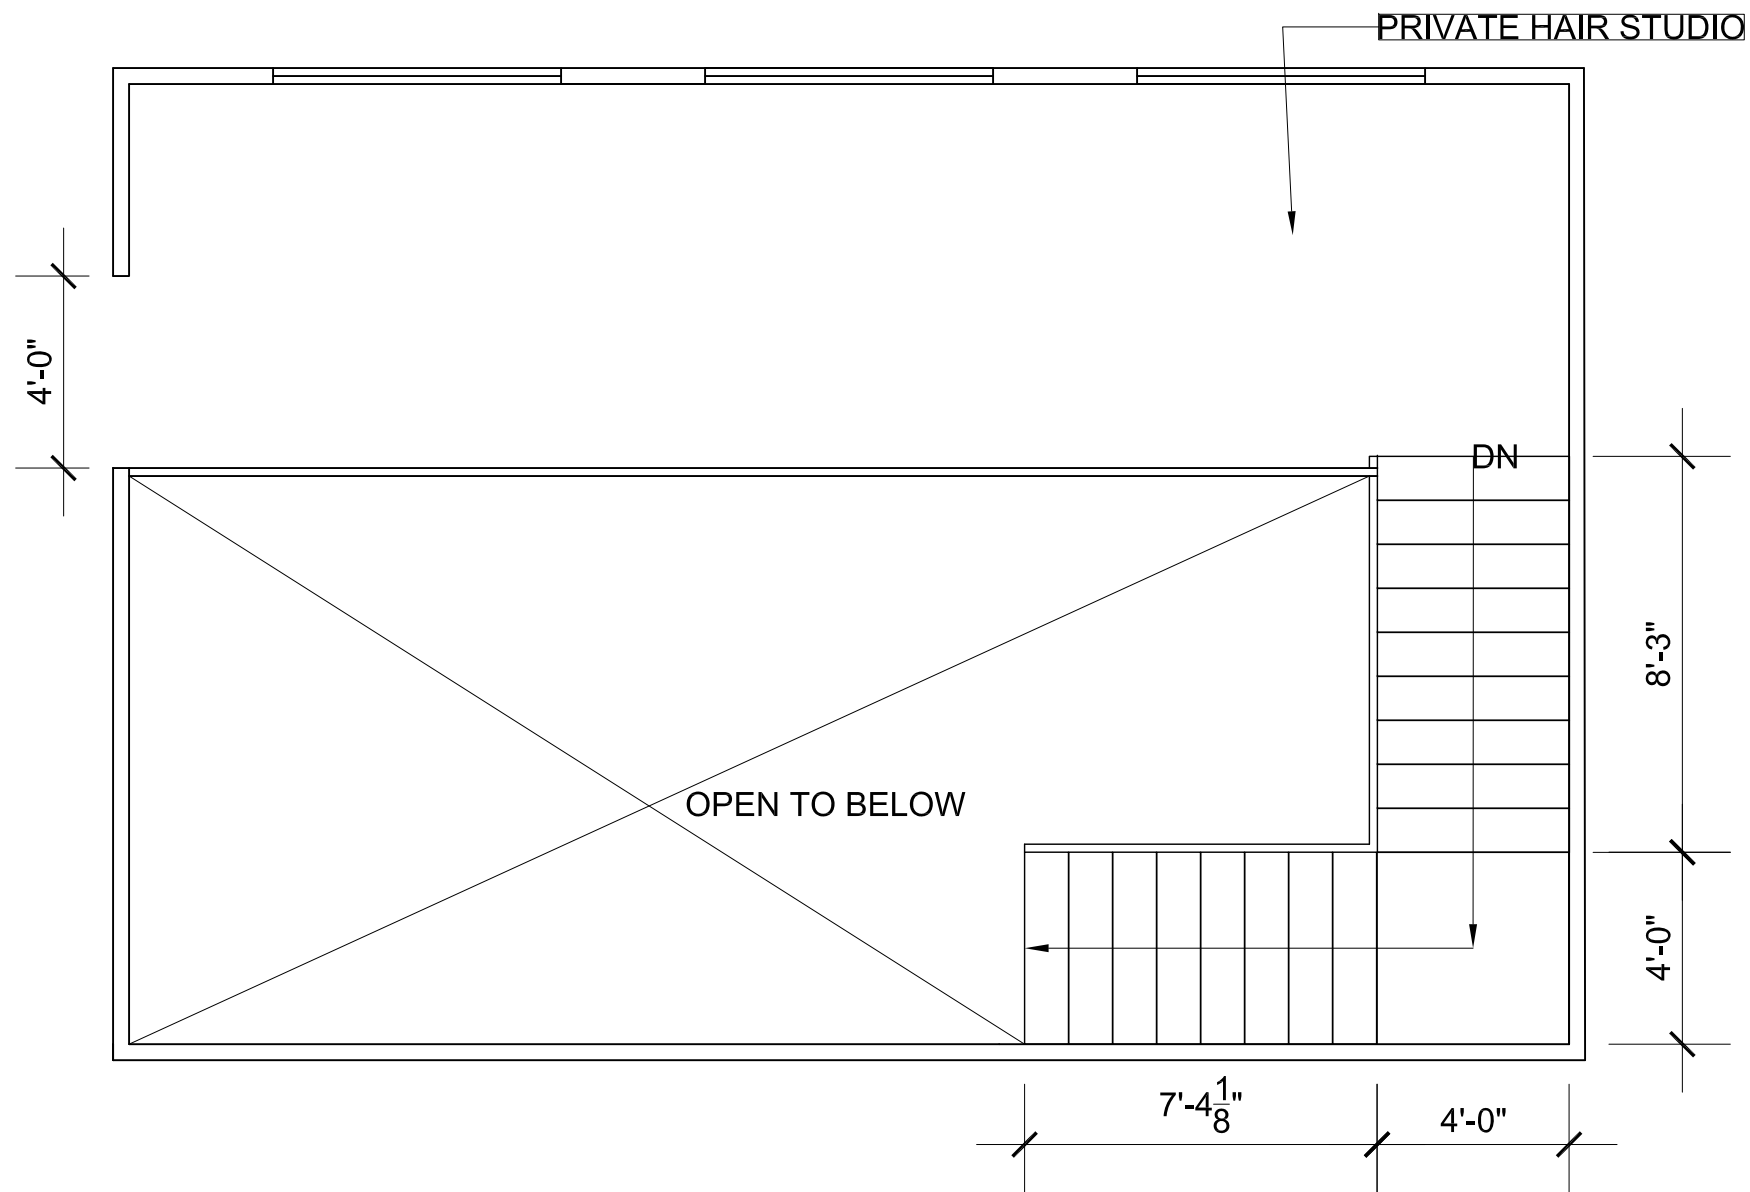

1 PARTITION PLAN - SECOND FLOOR
 $\frac{1}{4}'' = 1'-0''$


General Notes

No.	Revision/Issue	Date

Firm Name and Address
Rachel Skala

Project Name and Address
Studio Lobby

Project	Sheet
Date	A1.2
Scale	

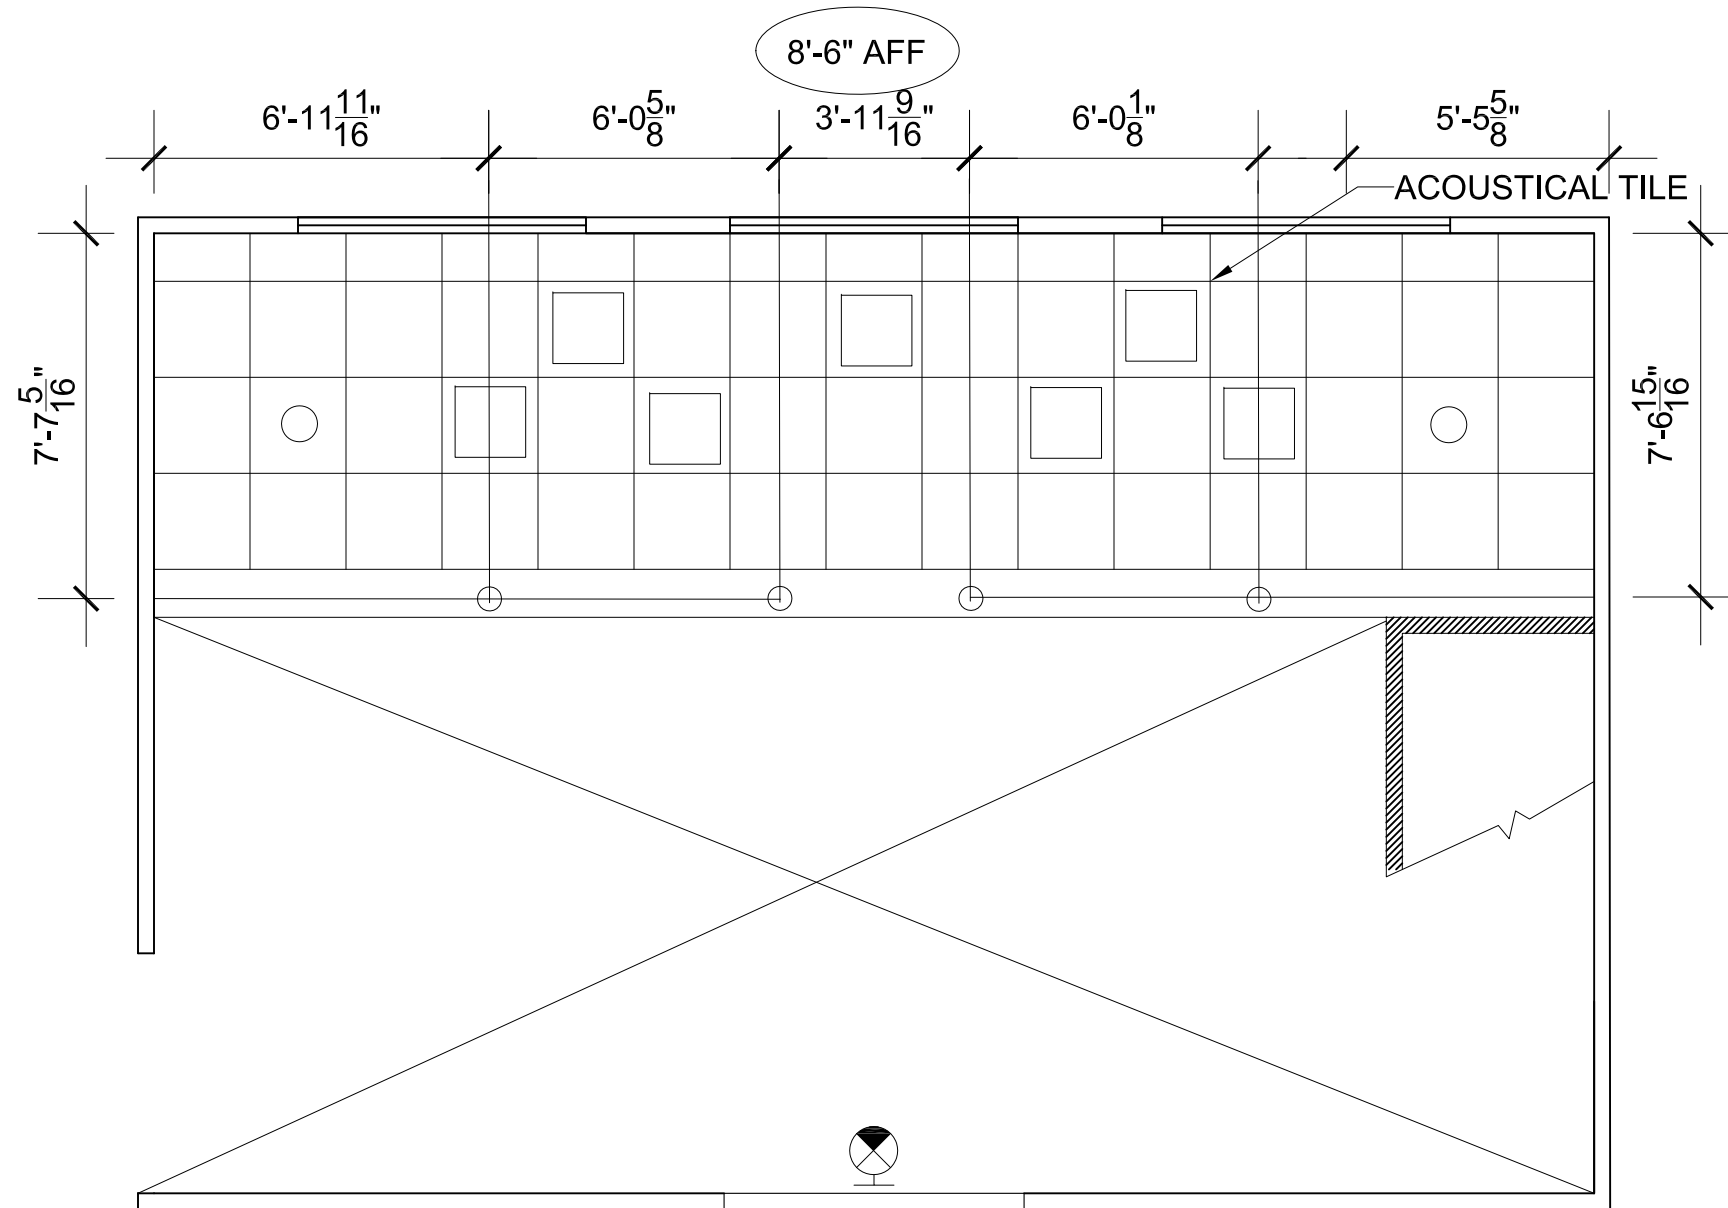

1

REFLECTED CEILING PLAN - FIRST FLOOR

1/4" = 1'-0"

General Notes

No.	Revision/Issue	Date


Firm Name and Address

Rachel Skala

Project Name and Address

Studio Lobby

Project	Sheet
Date	A2.1
Scale	

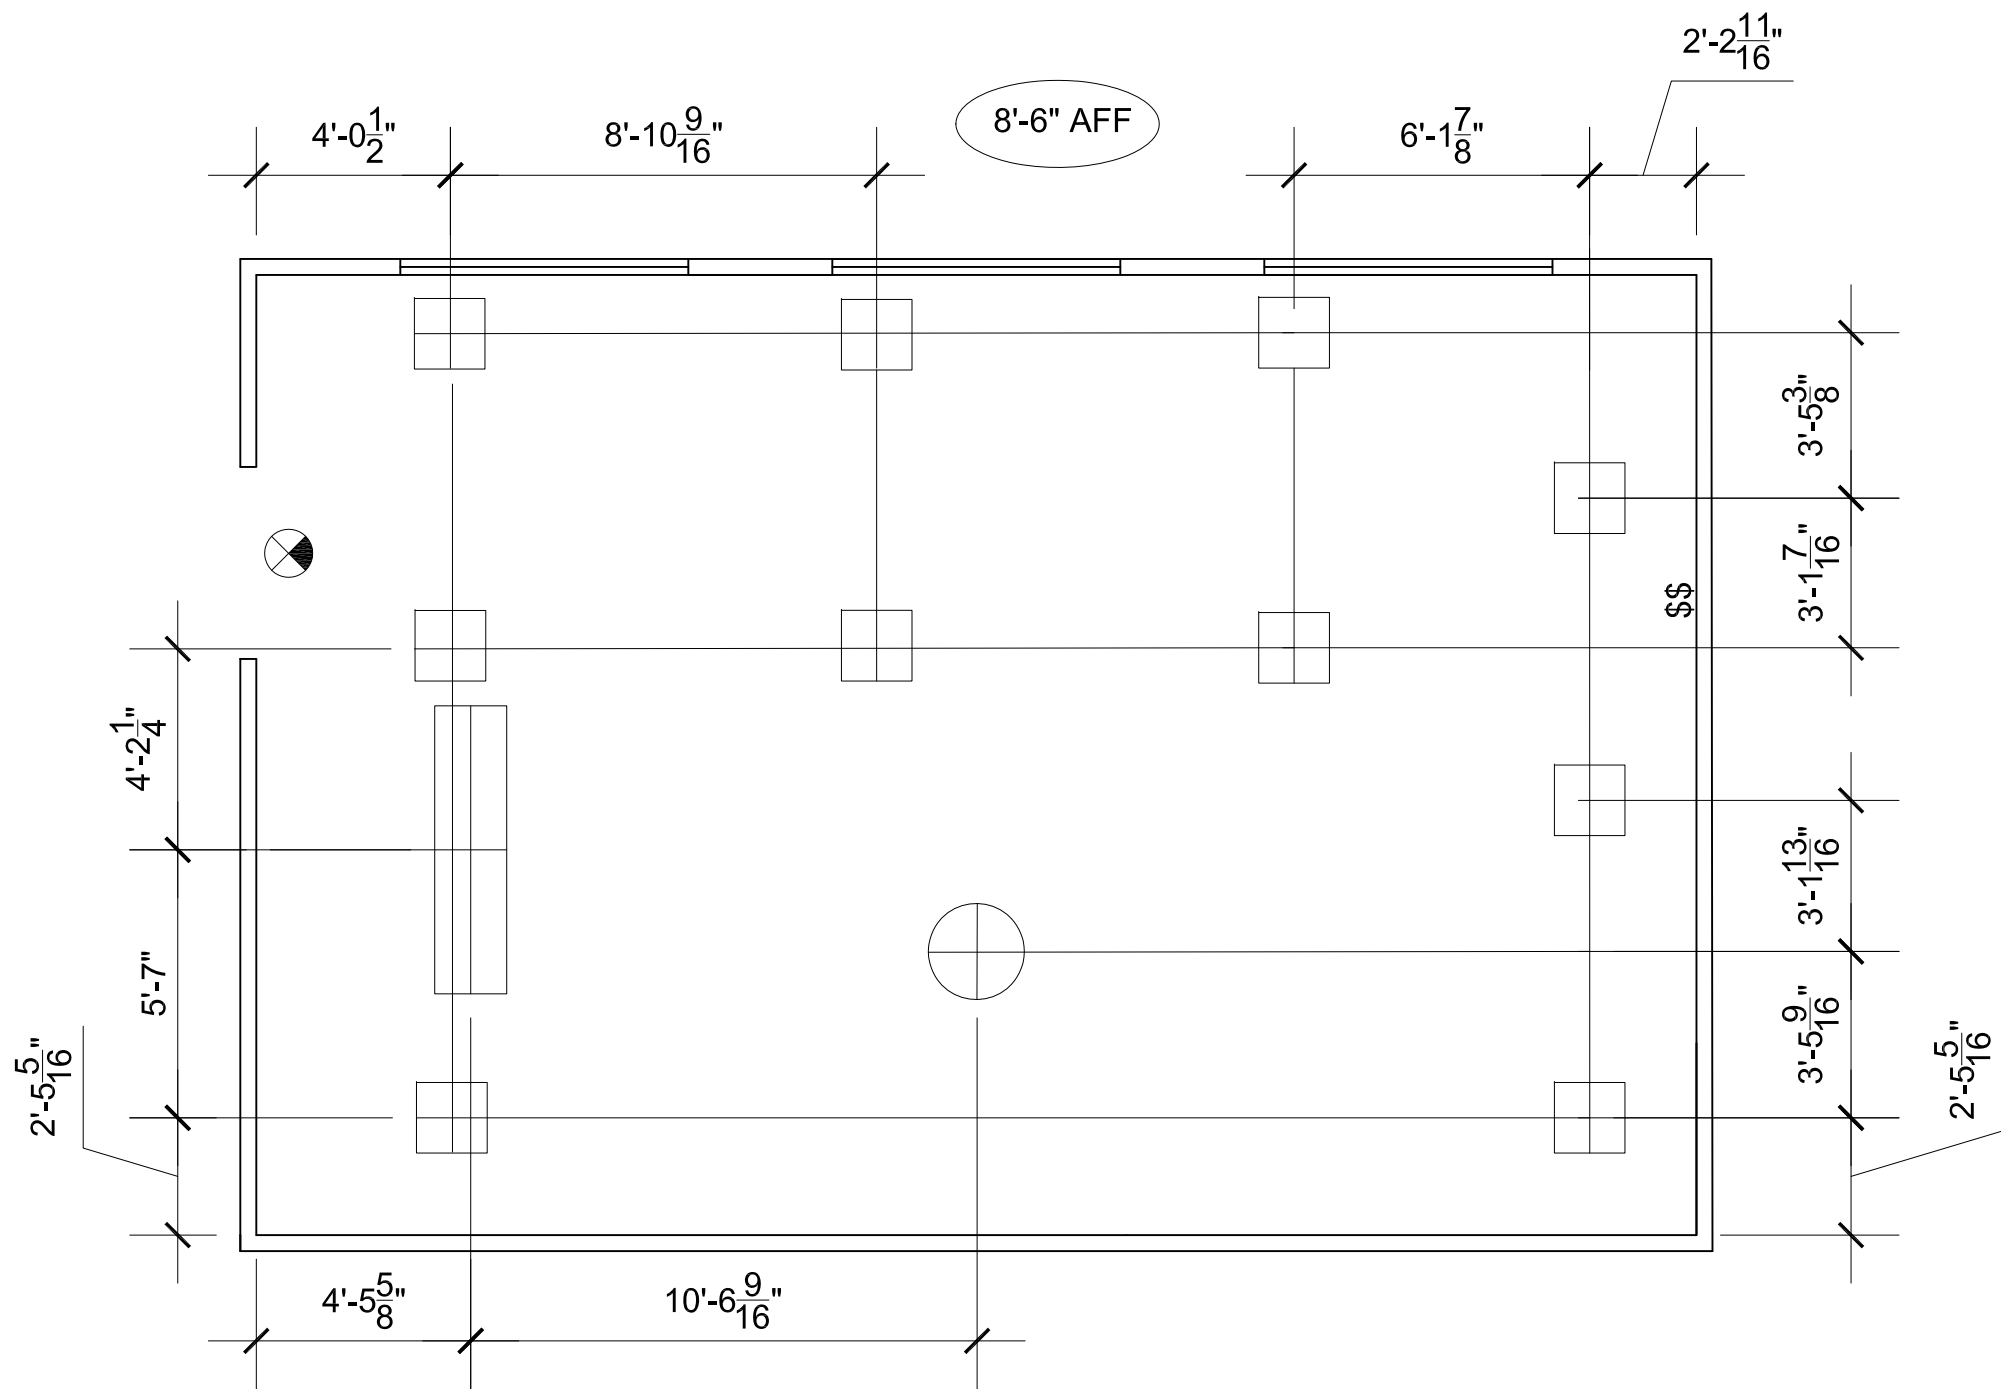

1 REFLECTED CEILING PLAN - SECOND FLOOR

1/4" = 1'-0"

General Notes

No.	Revision/Issue	Date

Firm Name and Address

Rachel
Skala

Project Name and Address

Studio
Lobby


Project

Date

Scale

Sheet

A2.2

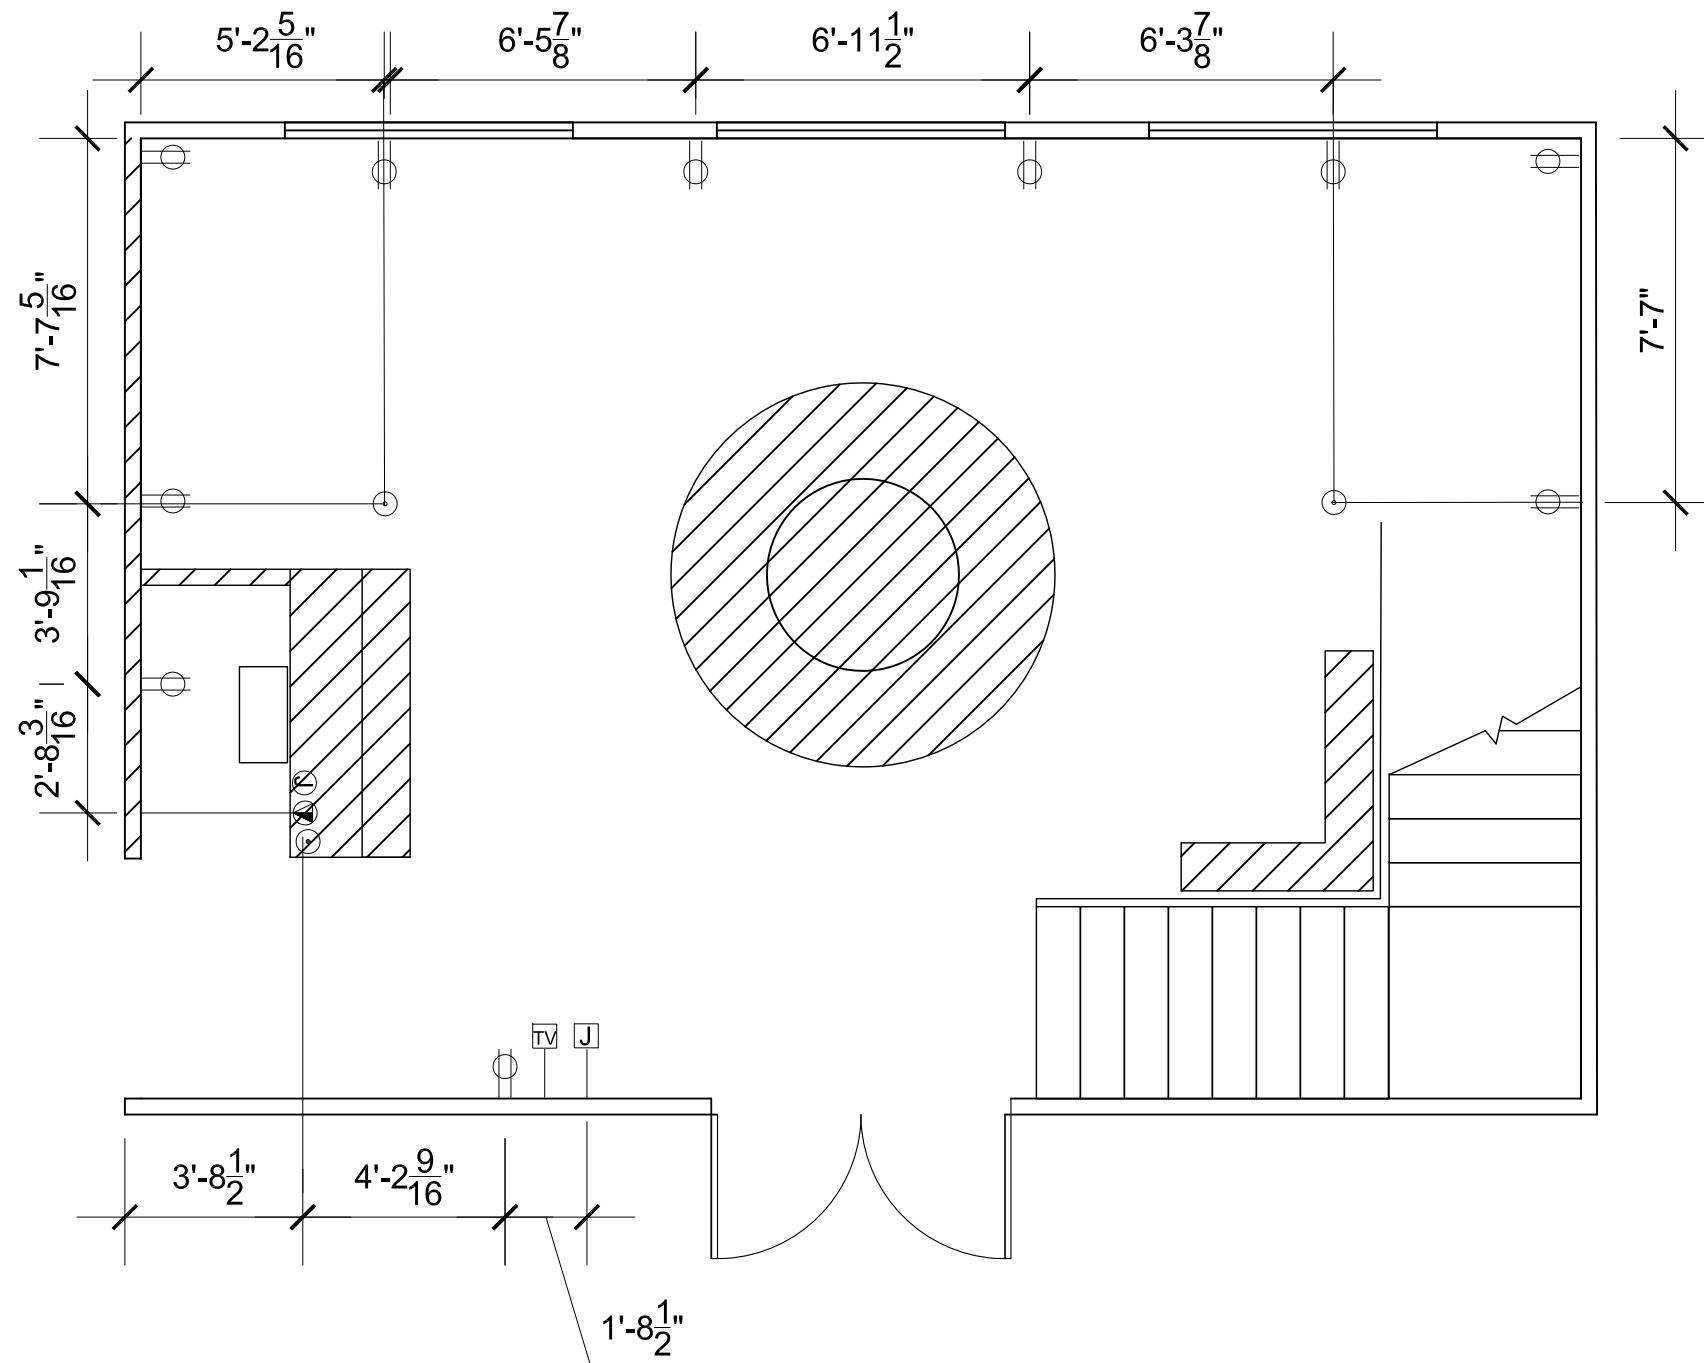

1 POWER AND TELECOM PLAN - FIRST FLOOR
 $\frac{1}{4}'' = 1'-0''$


General Notes

No.	Revision/Issue	Date

Firm Name and Address
Rachel Skala

Project Name and Address
Studio Lobby

Project	Sheet
Date	A3.1
Scale	

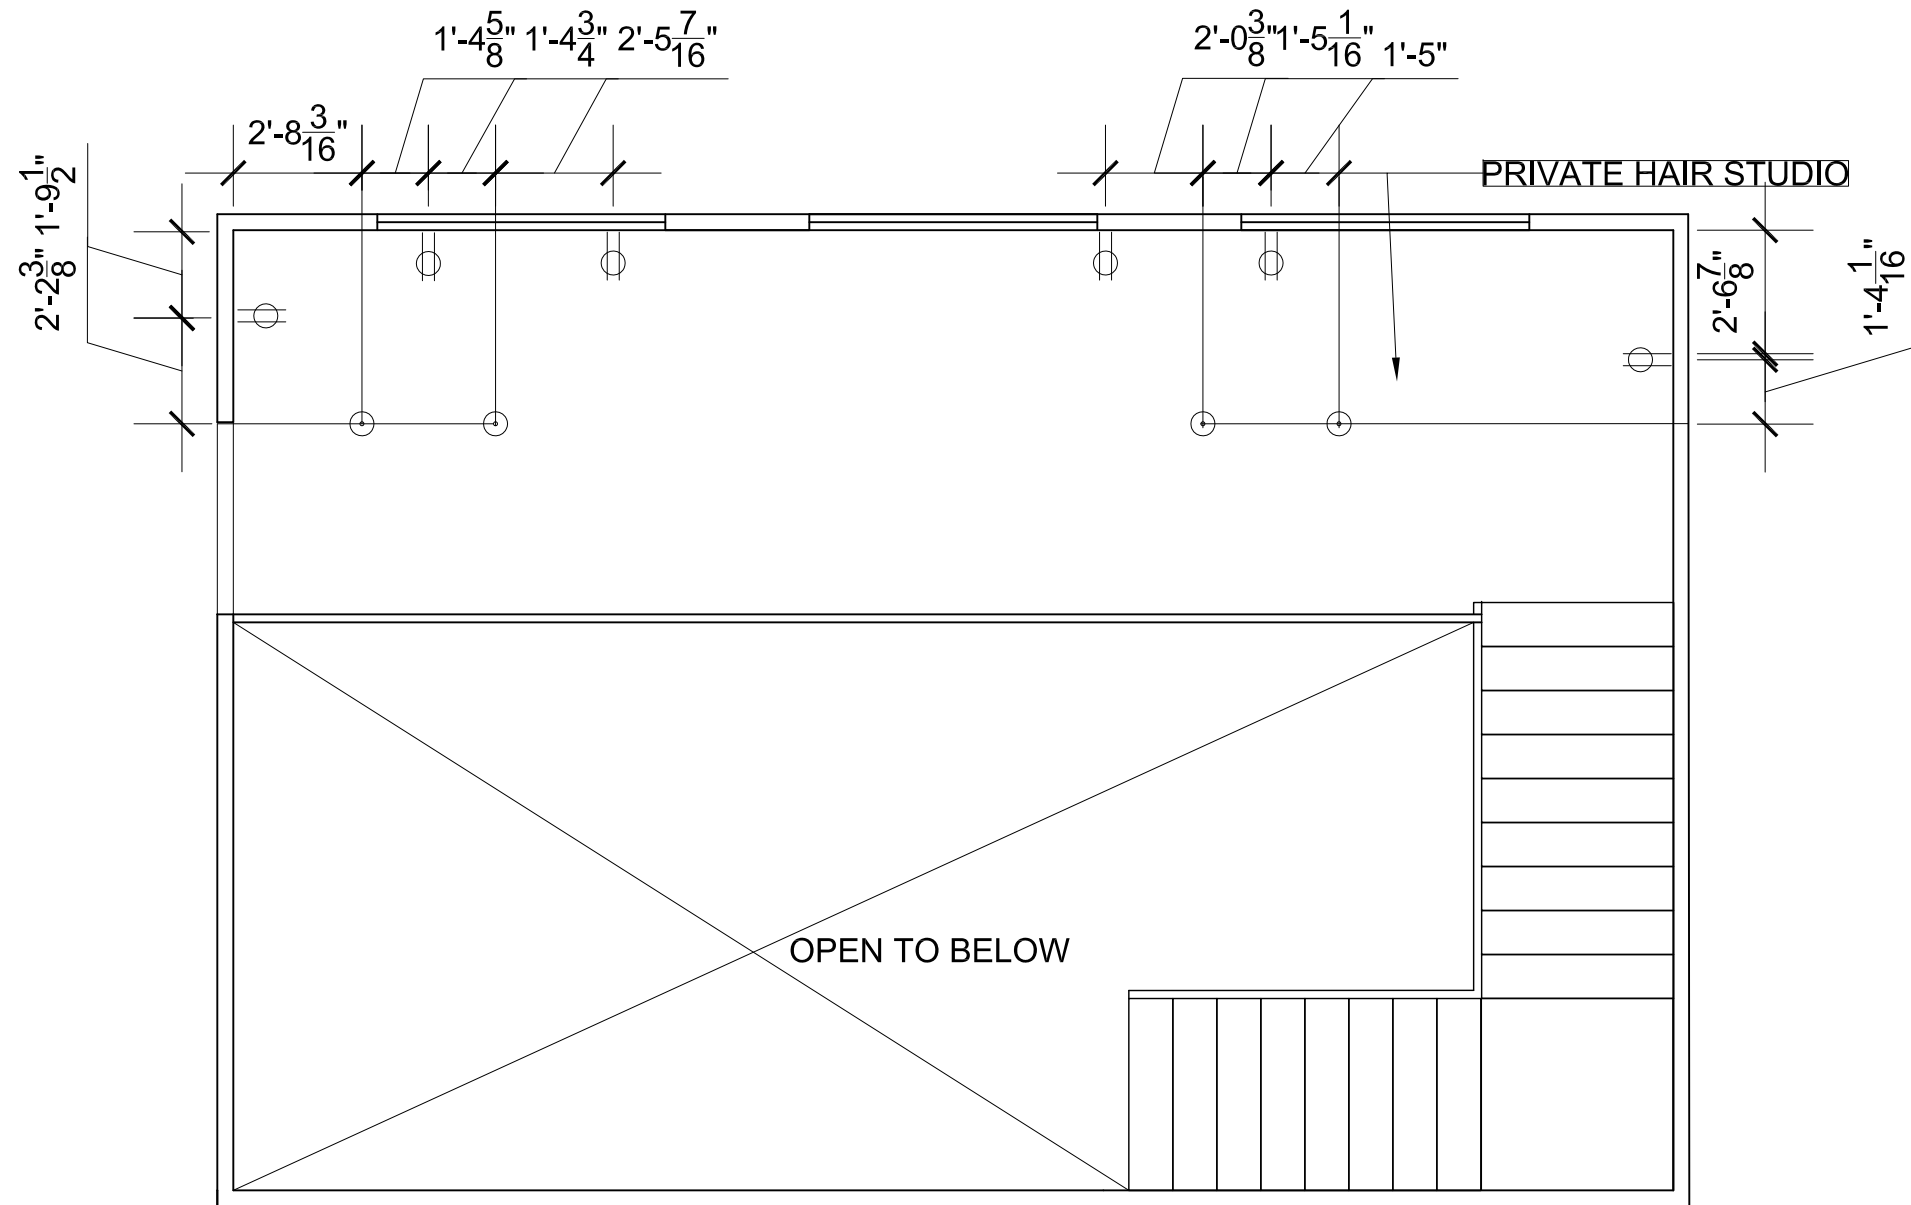

1 POWER AND TELECOM PLAN - SECOND FLOOR
 $\frac{1}{4}'' = 1'-0''$


General Notes

No.	Revision/Issue	Date

Firm Name and Address
Rachel Skala

Project Name and Address
Studio Lobby

Project	Sheet
Date	A3.2
Scale	

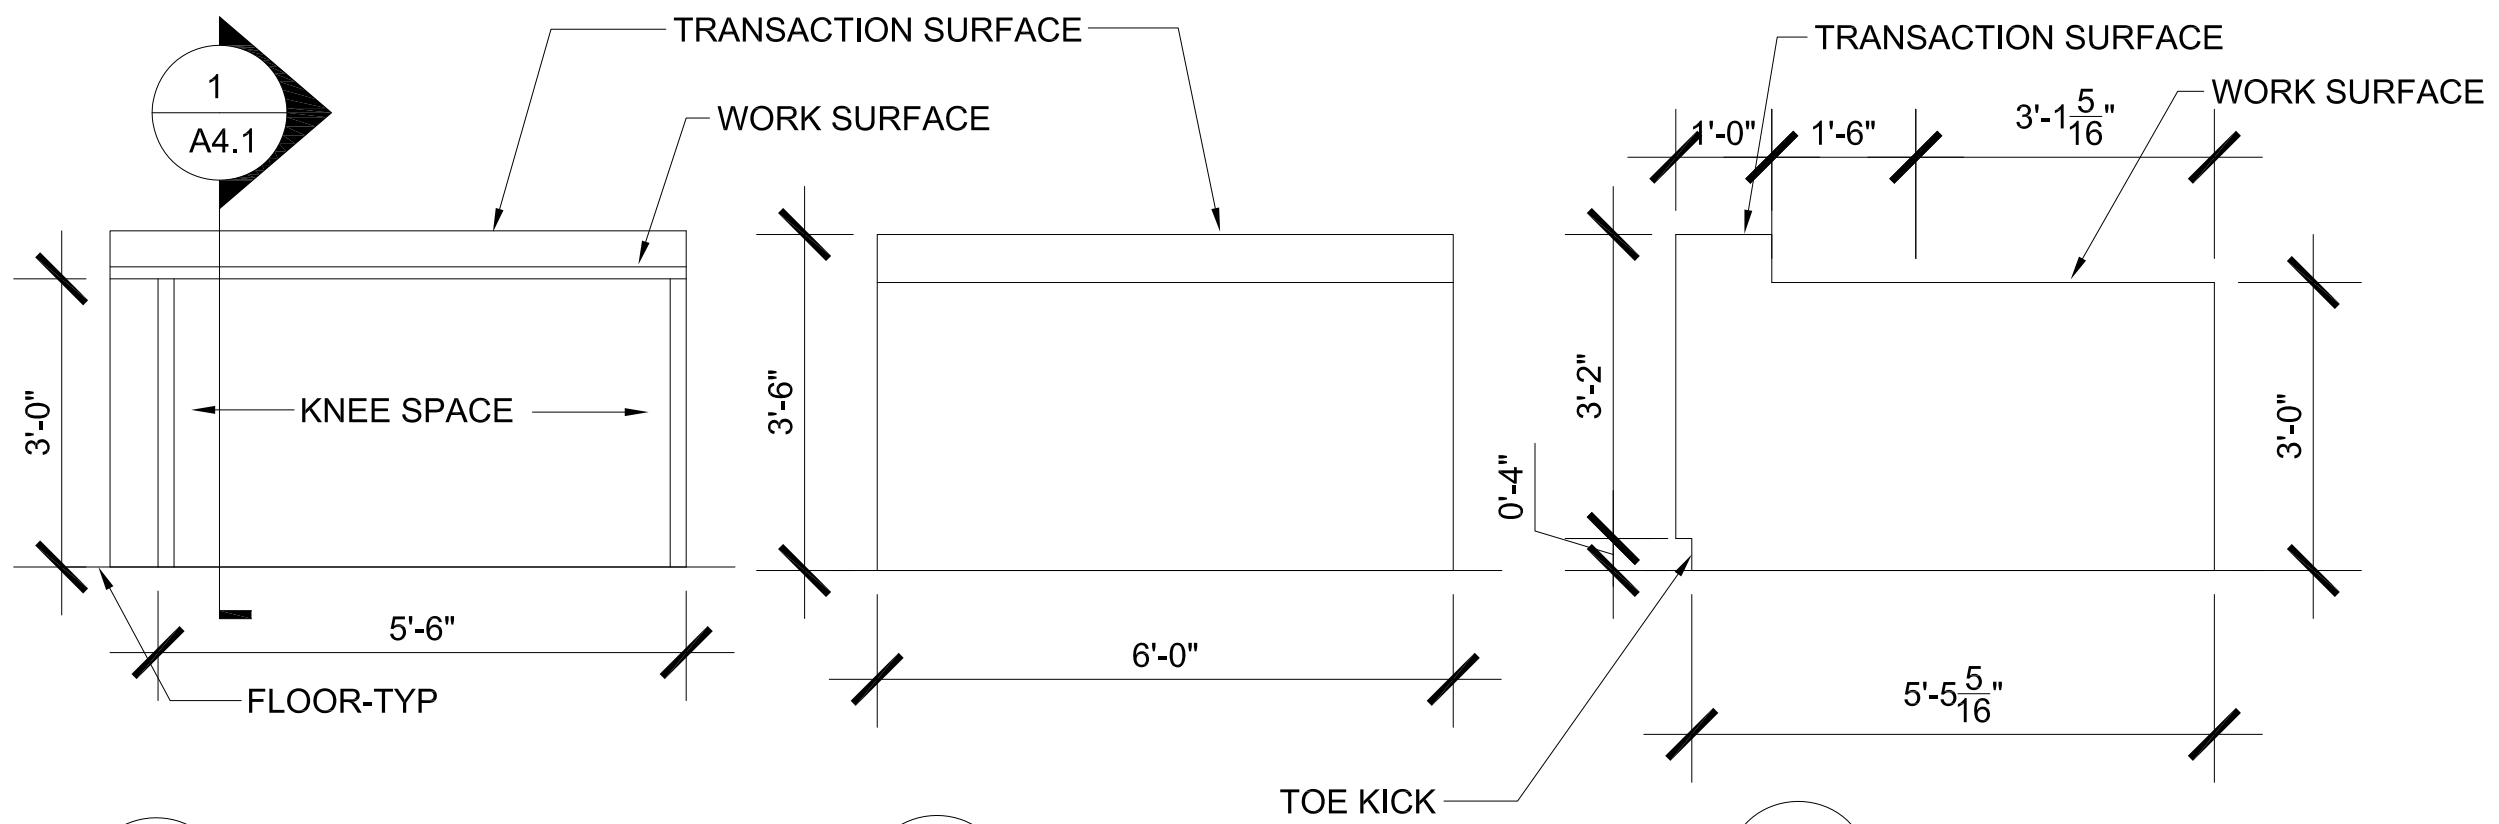

1 BACK ELEVATION
 $\frac{1}{2}'' = 1'-0''$

2 FRONT ELEVATION
 $\frac{1}{2}'' = 1'-0''$

3 SIDE ELEVATION
 $\frac{1}{2}'' = 1'-0''$

General Notes

No.	Revision/Issue	Date


Firm Name and Address

Rachel Skala


Project Name and Address

Studio Lobby

Project	Sheet
Date	A4.1
Scale	

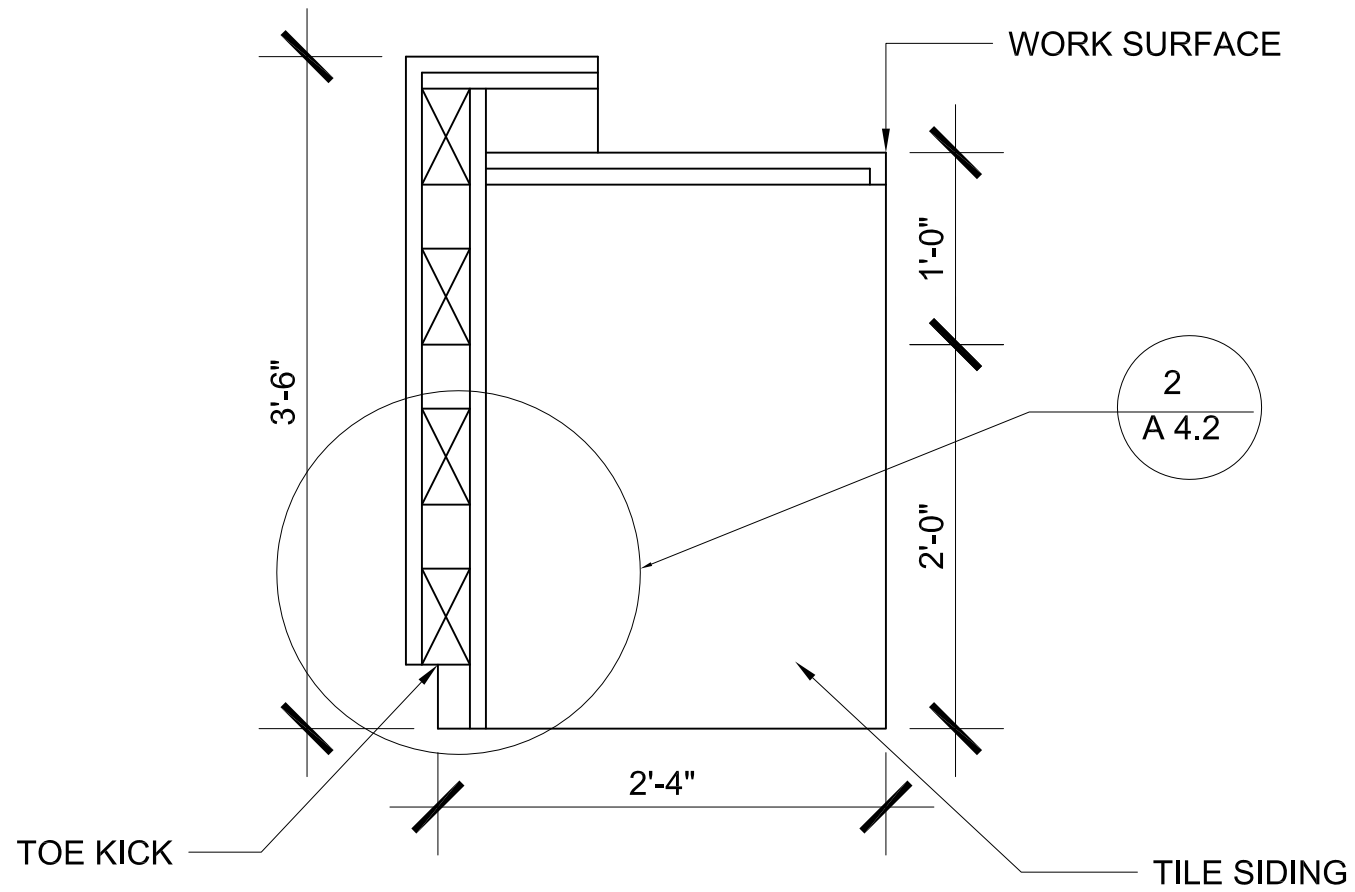

PLYWOOD

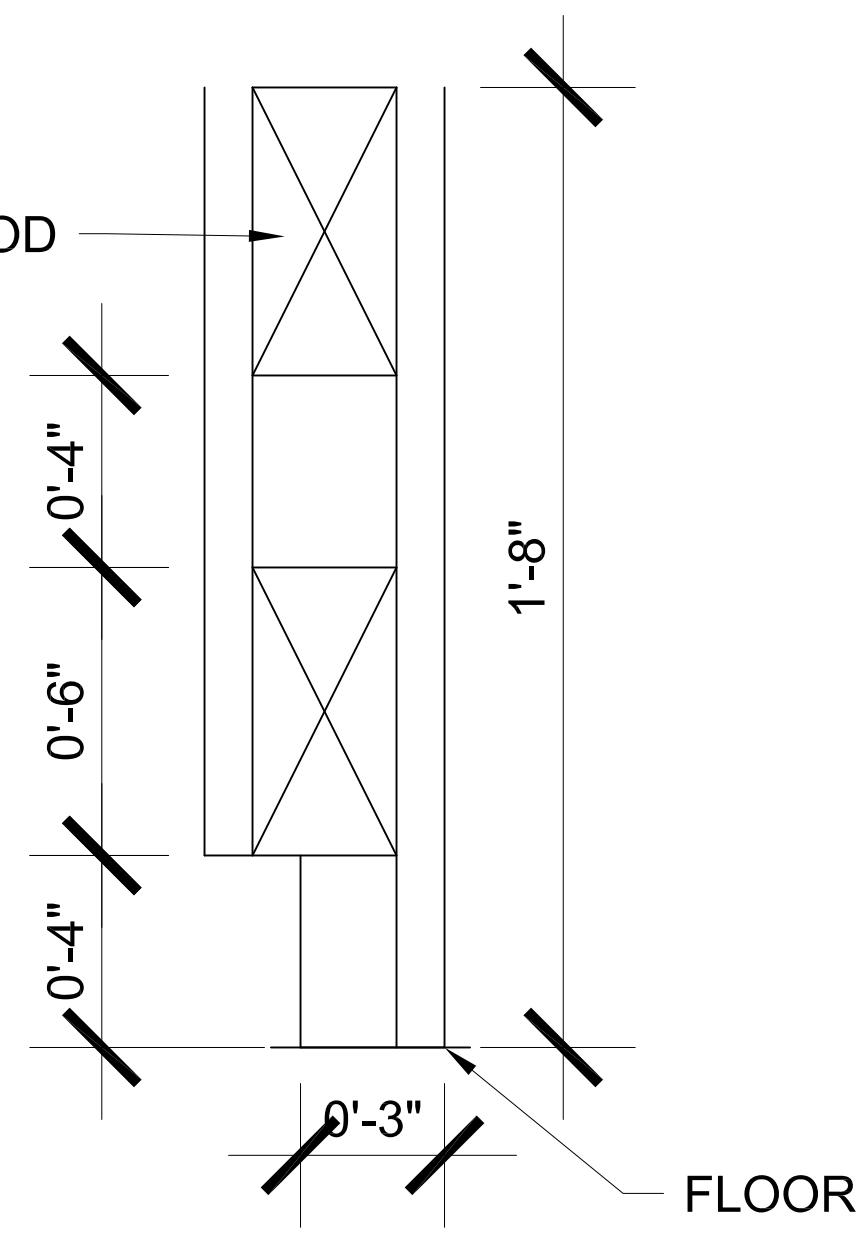

1 SECTION
1" = 1'-0"

2 DETAIL
3" = 1'-0"

General Notes

No.	Revision/Issue	Date


Firm Name and Address

Rachel Skala

Project Name and Address

Studio Lobby

Project	Sheet
Date	A4.2
Scale	

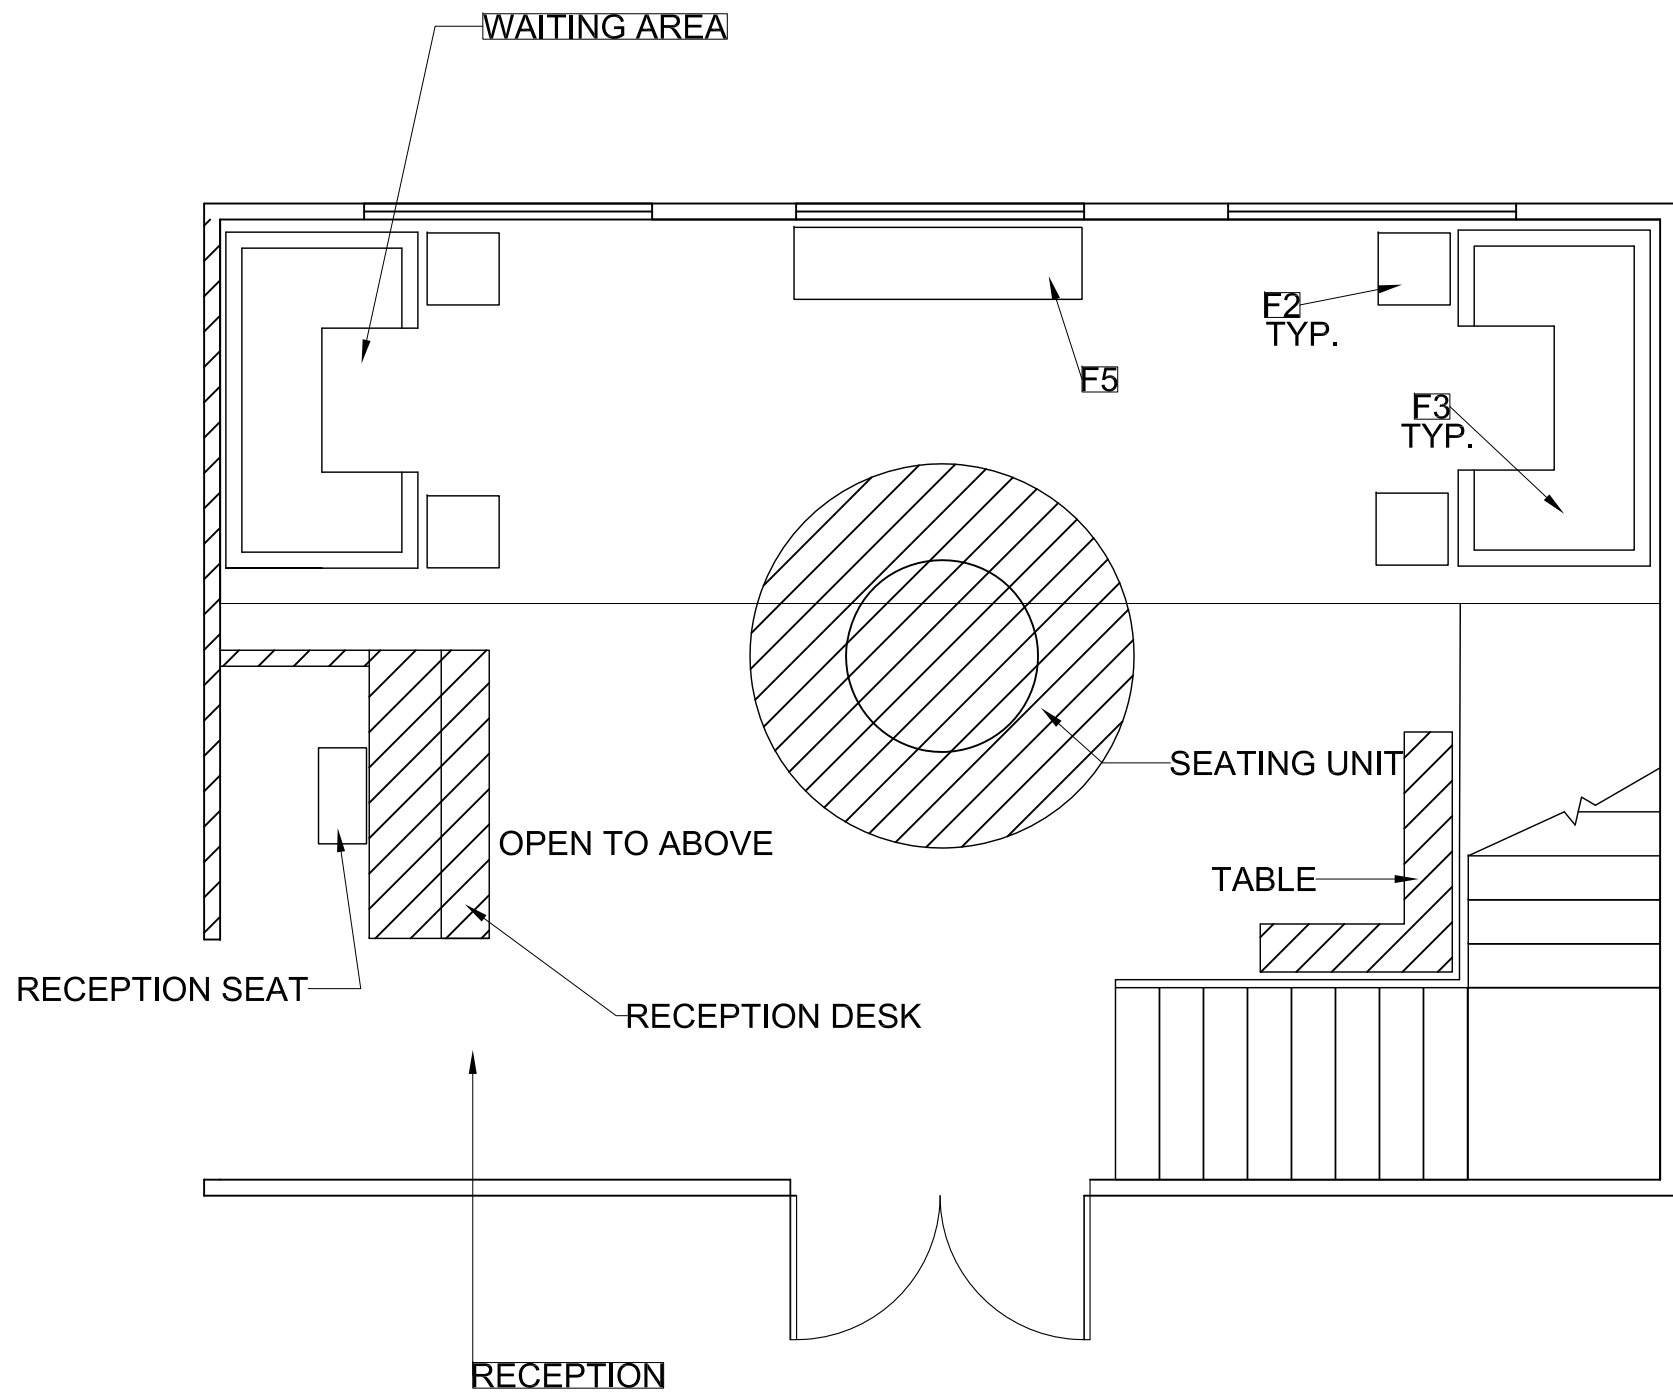

1 FURNITURE PLAN - FIRST FLOOR
 $\frac{1}{4}'' = 1'-0''$

General Notes

No.	Revision/Issue	Date


Firm Name and Address

Rachel Skala

Project Name and Address

Studio Lobby

Project	Sheet
Date	F1.1
Scale	

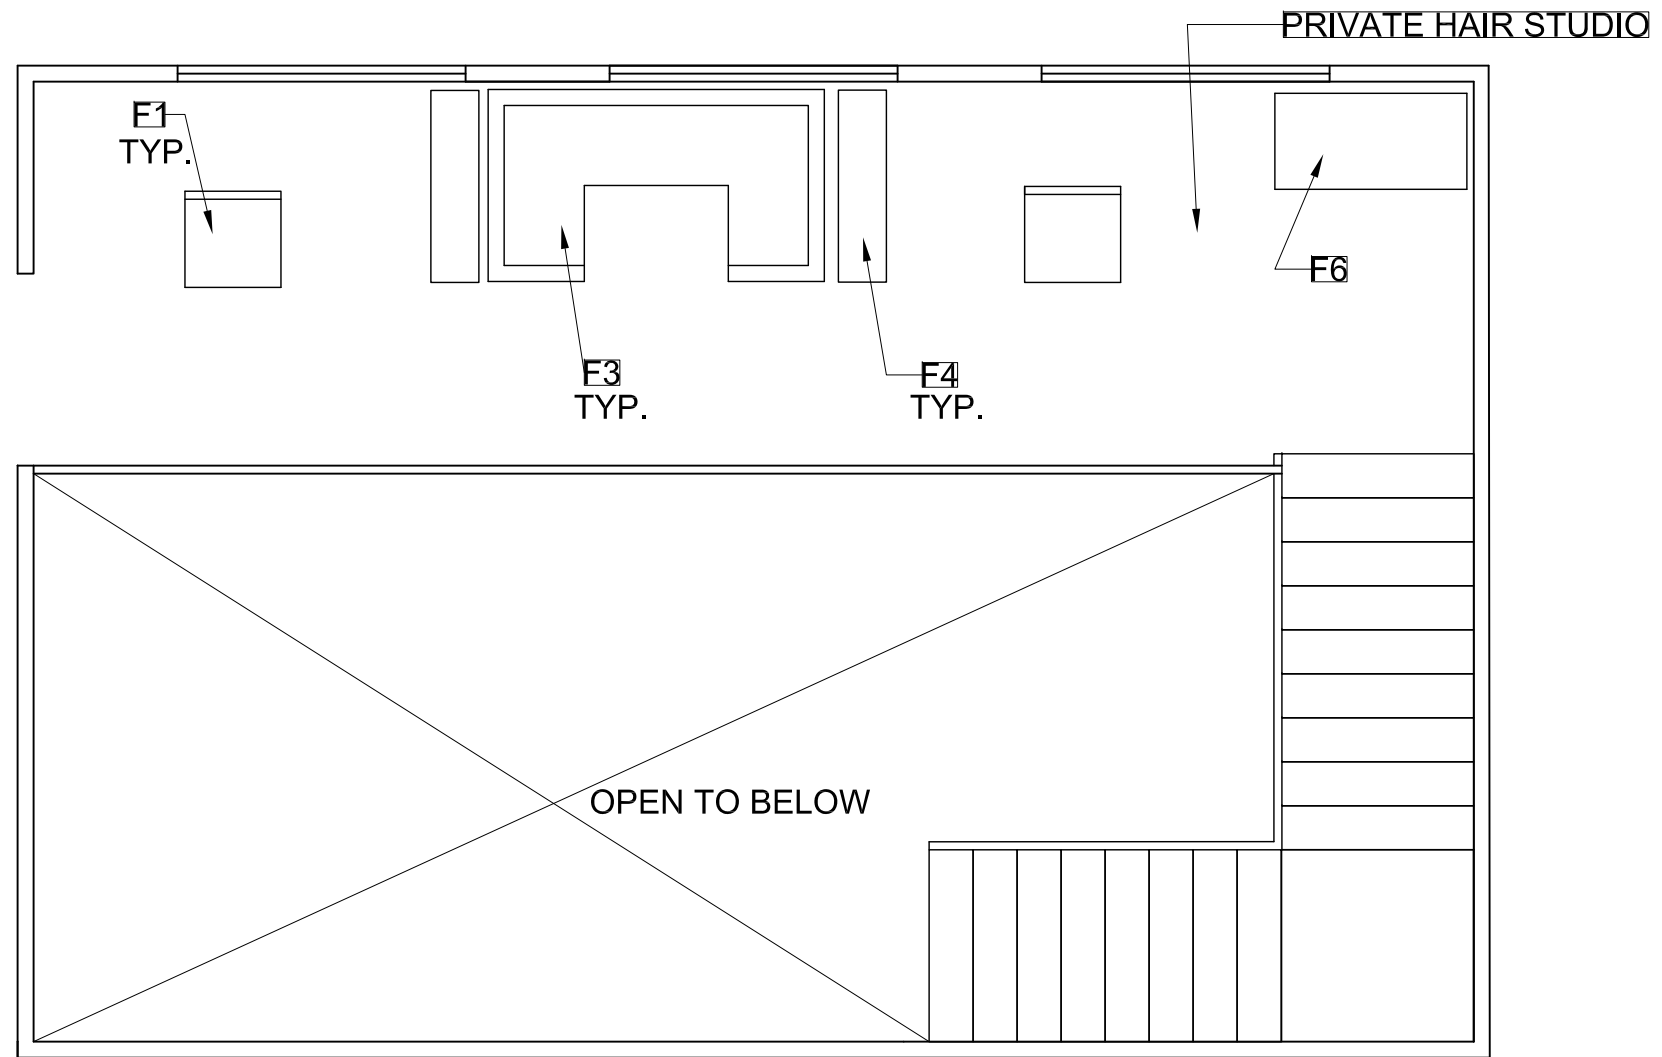

1 FURNITURE PLAN - SECOND FLOOR
 $\frac{1}{4}'' = 1'-0''$

General Notes

No.	Revision/Issue	Date

Firm Name and Address

Rachel Skala

Project Name and Address

Studio Lobby

Project	Sheet
Date	F1.2
Scale	

FURNITURE SCHEDULE				
FURNITURE CODE	ITEM	MANUFACT.	MODEL	NOTES
F1	STUDIO SEAT	TBD	TBD	
F2	SIDE TABLE	TBD	TBD	
F3	LOUNGE COUCH	TBD	TBD	
F4	STORAGE TABLE	TBD	TBD	
F5	BENCH	TBD	TBD	
F6	BENCH	TBD	TBD	

1 FURNITURE SCHEDULE
 $\frac{1}{4}'' = 1'-0''$

General Notes

<small>No.</small>	<small>Revision/Issue</small>	<small>Date</small>

Firm Name and Address

Rachel Skala

Project Name and Address

Studio Lobby

<small>Project</small>	<small>Sheet</small>
<small>Date</small>	F1.3
<small>Scale</small>	