

① PARTITION PLAN 2ND FLOOR
 SCALE: 0'- $\frac{1}{4}$ " = 1'-0"


General Notes

No.	Revision/Issue	Date

Firm Name and Address
 BAYLEE
 VINCENT

Project Name and Address
 IDSN 2281
 RECEPTION

Project	Sheet
Date	A1.2
Scale	SEE DWG

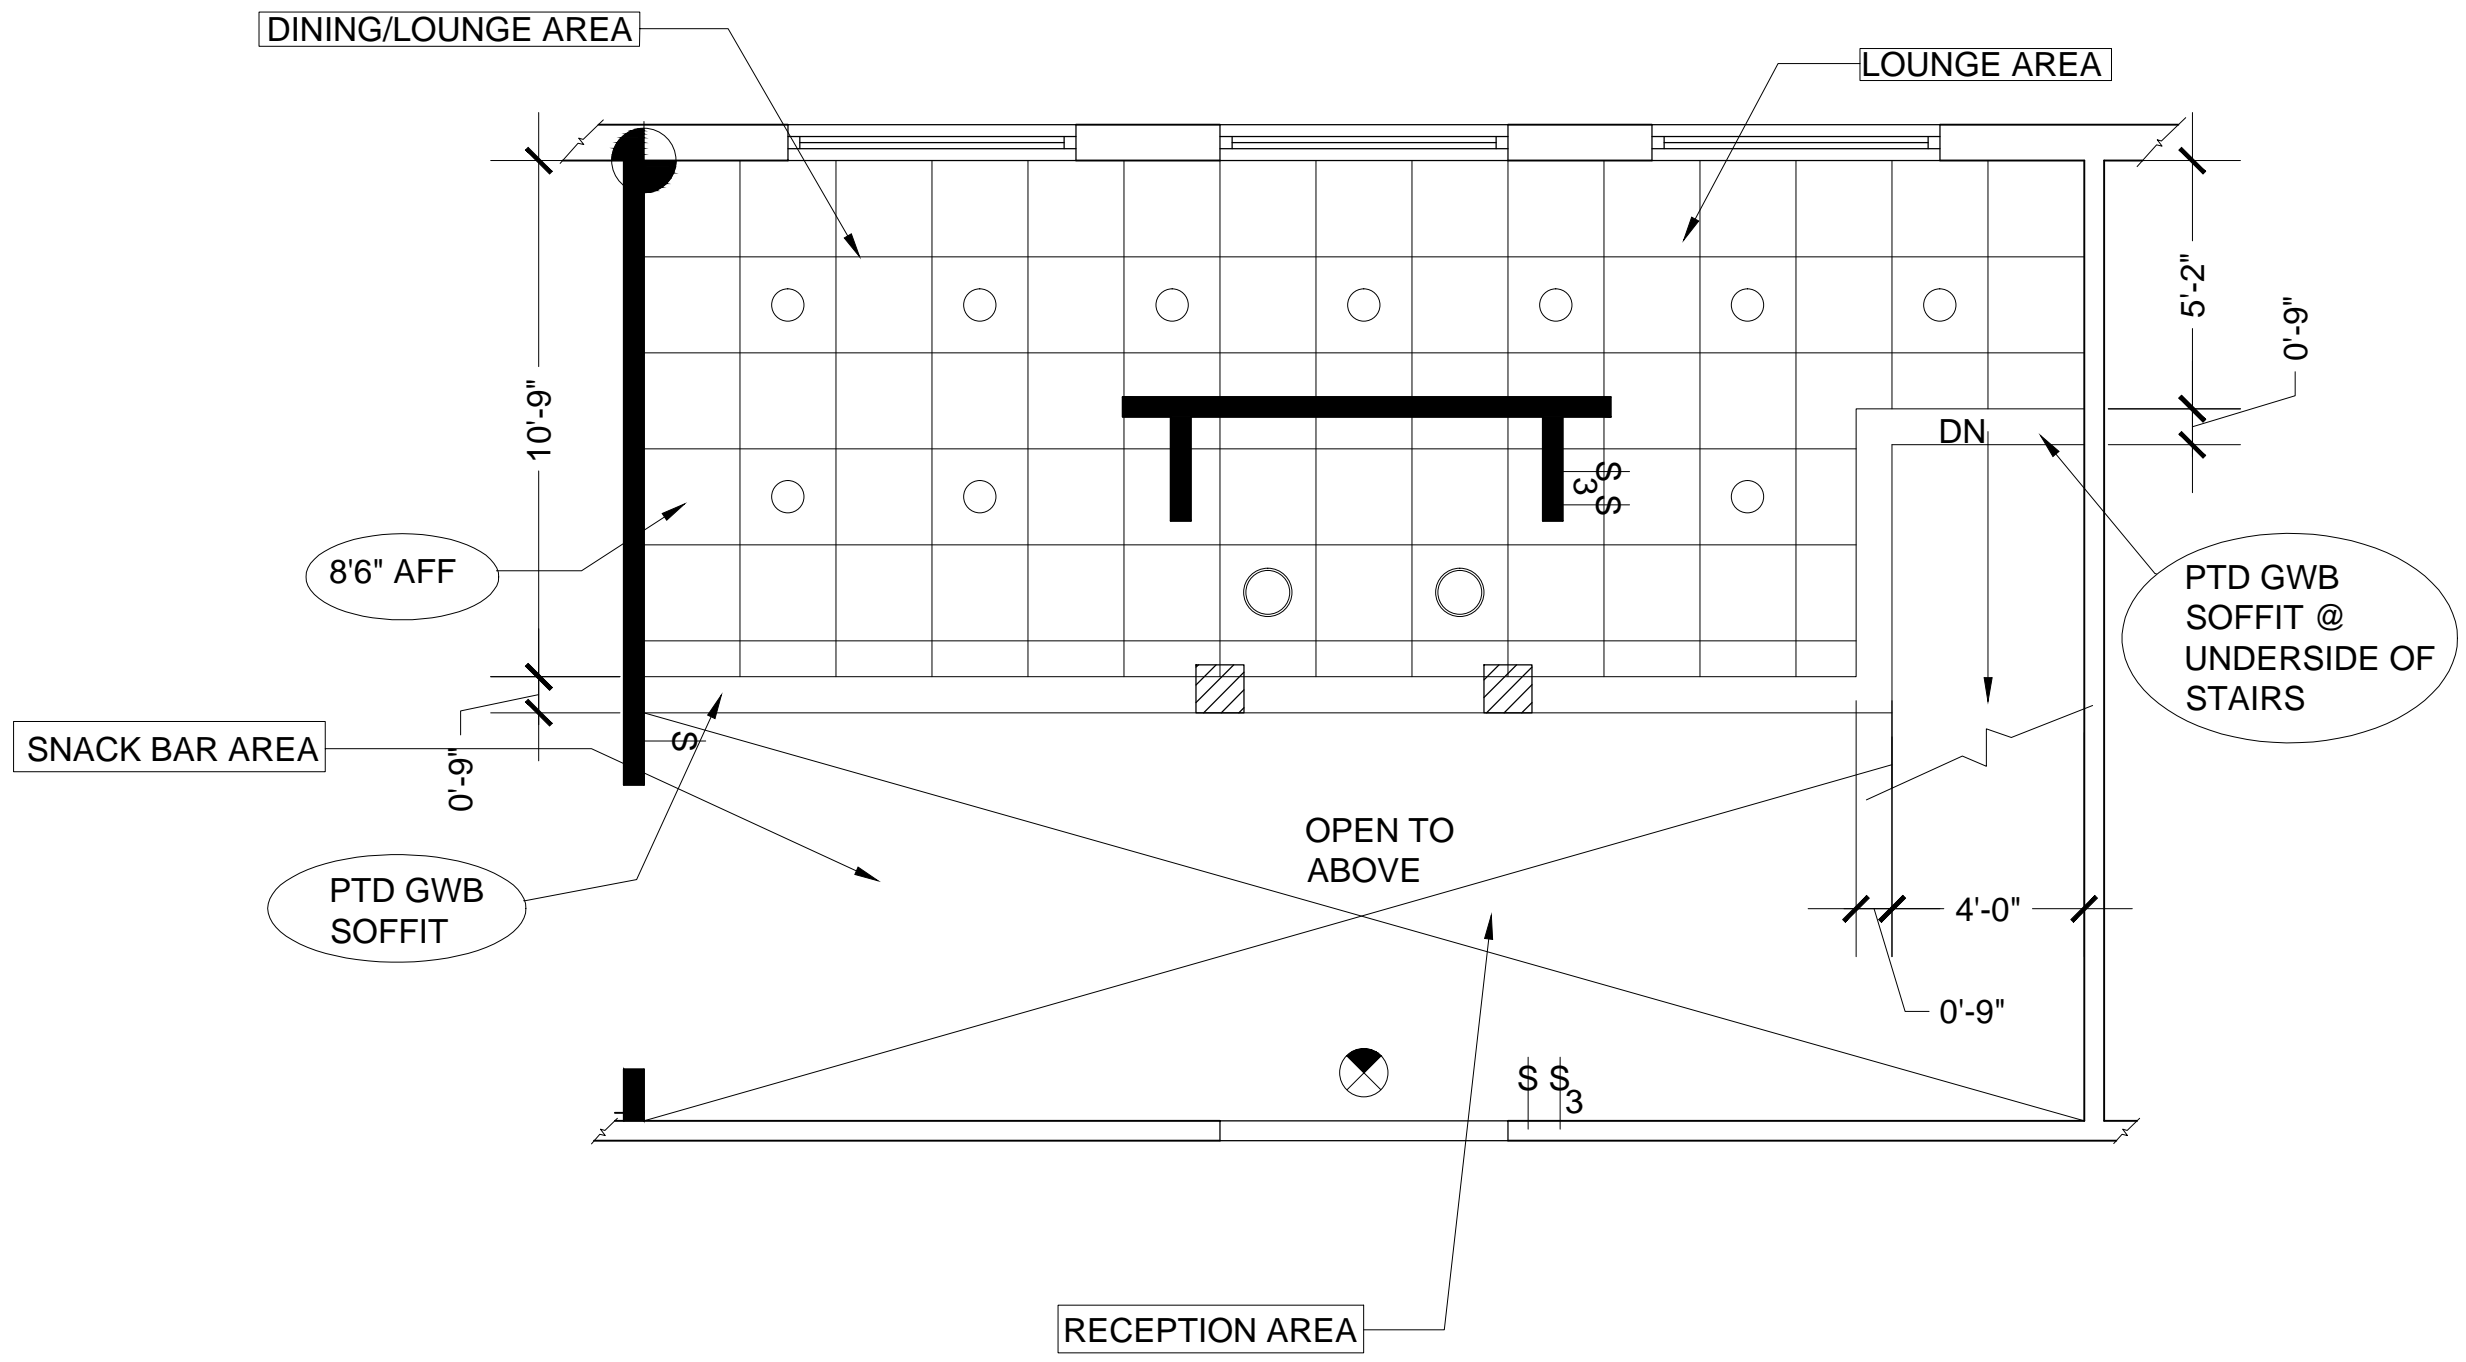

1 REFLECTED CEILING PLAN 1ST FLOOR
 SCALE: 0'-1/4" = 1'-0"


General Notes

No.	Revision/Issue	Date

Firm Name and Address
 BAYLEE
 VINCENT

Project Name and Address
 IDSN 2281
 RECEPTION

Project	Sheet
Date	A2.1
Scale	SEE DWG

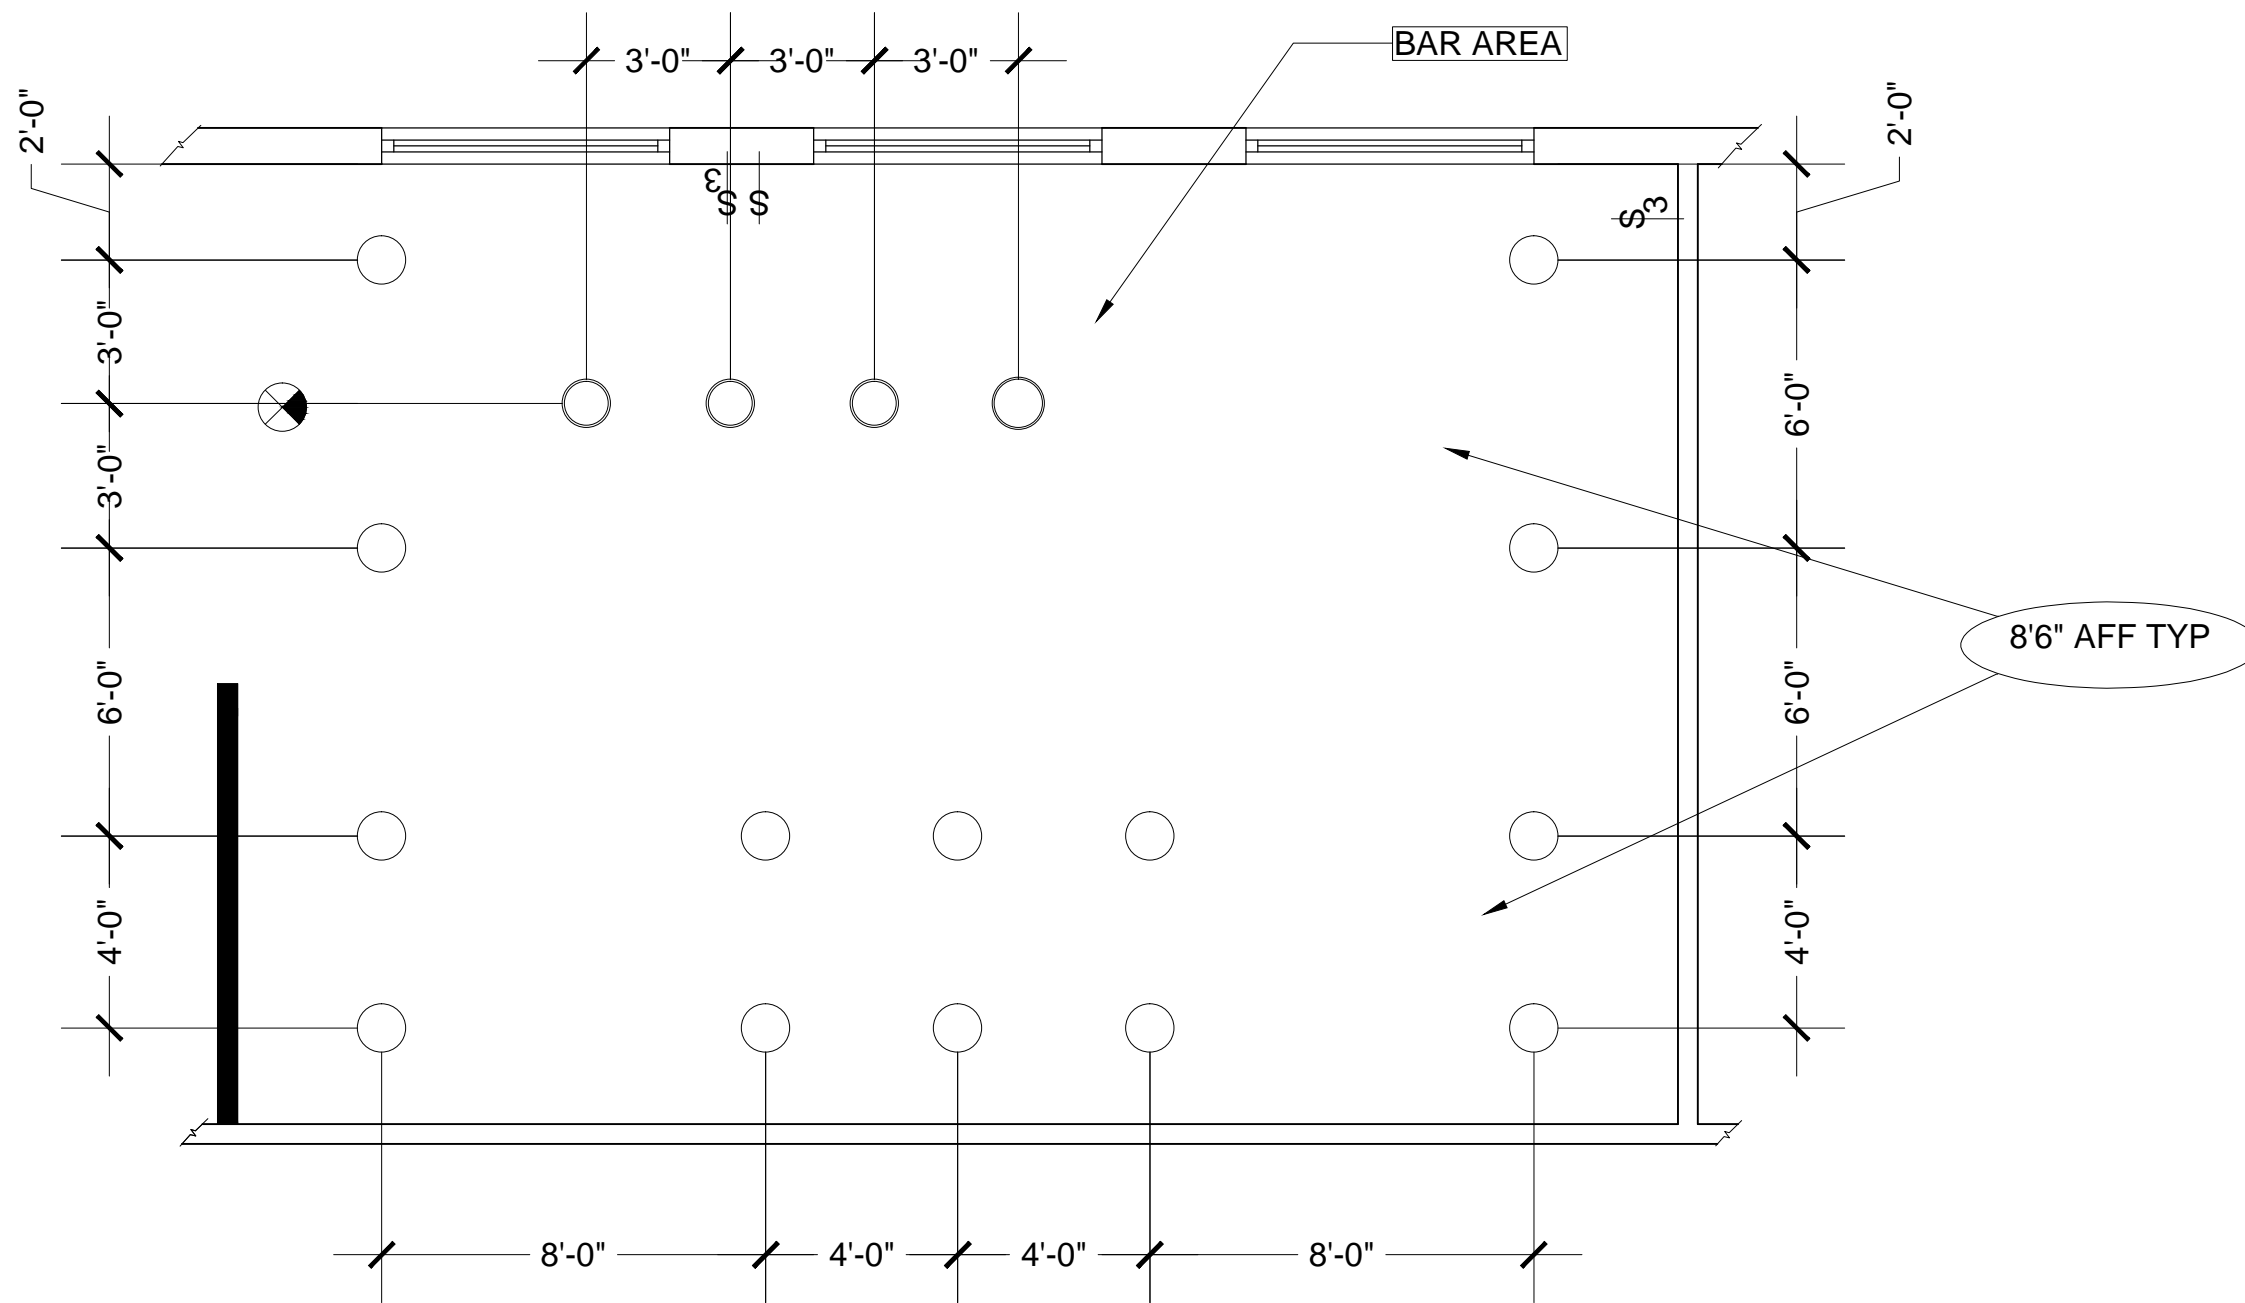

① REFLECTED CEILING PLAN 2ND FLOOR
 SCALE: 0'- $\frac{1}{4}$ " = 1'-0"


General Notes

No.	Revision/Issue	Date

Firm Name and Address
**BAYLEE
 VINCENT**

Project Name and Address
**IDSN 2281
 RECEPTION**

Project	Sheet
Date	A2.2
Scale	SEE DWG

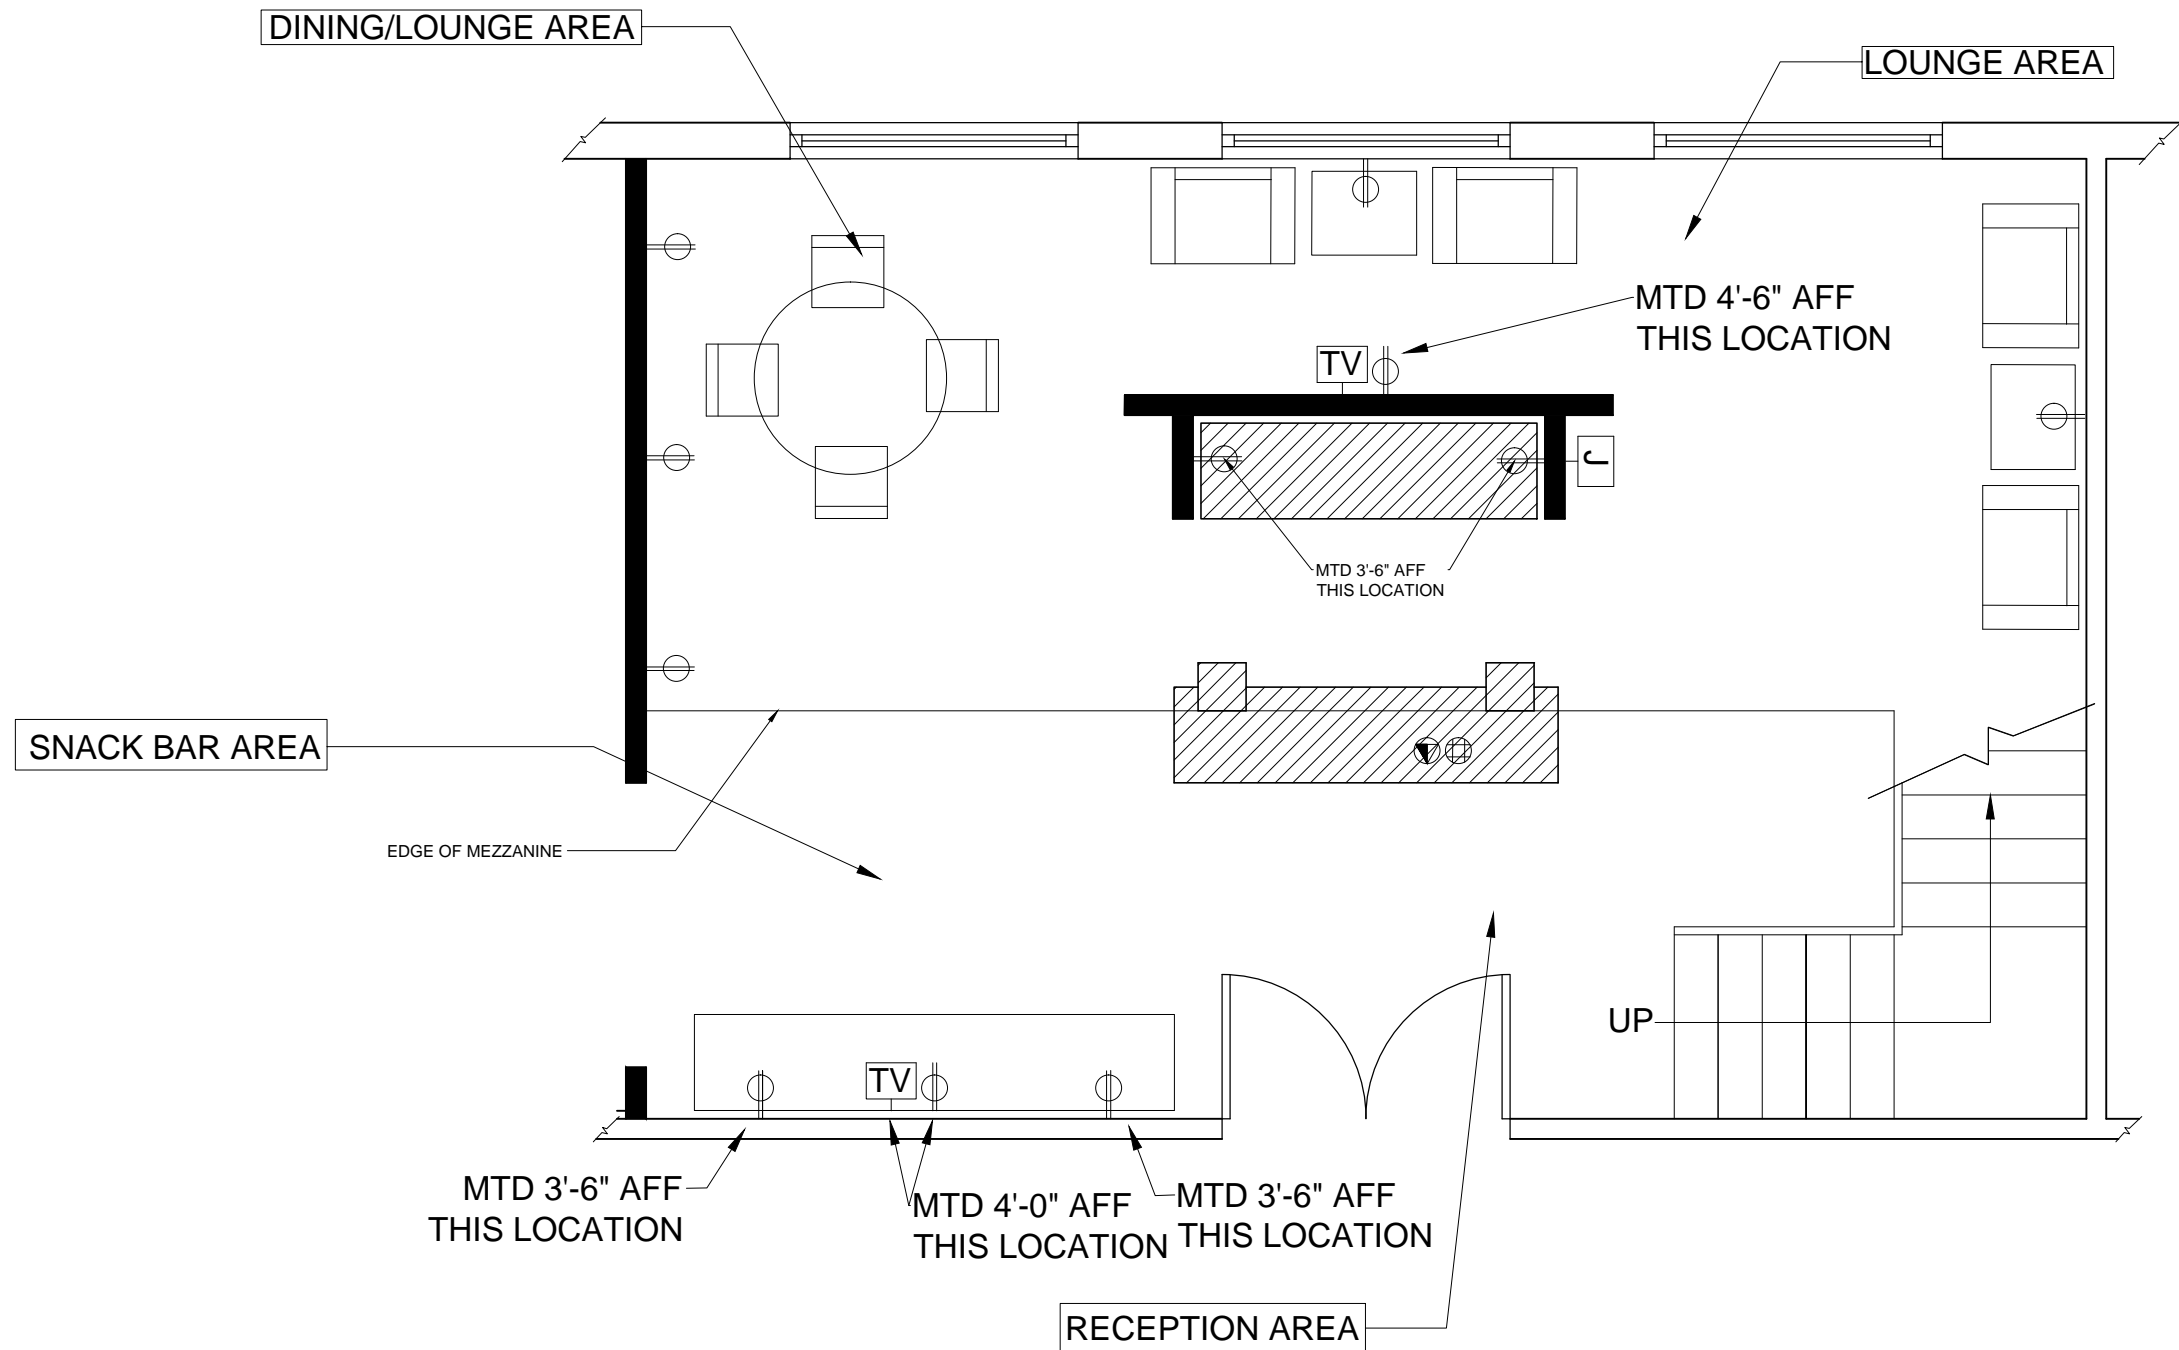

1 POWER AND TELECOM PLAN 1ST FLOOR
 SCALE: 0'- $\frac{1}{4}$ " = 1'-0"


General Notes

No.	Revision/Issue	Date

Firm Name and Address
 BAYLEE
 VINCENT

Project Name and Address
 IDSN 2281
 RECEPTION

Project	Sheet
Date	A3.1
Scale	SEE DWG

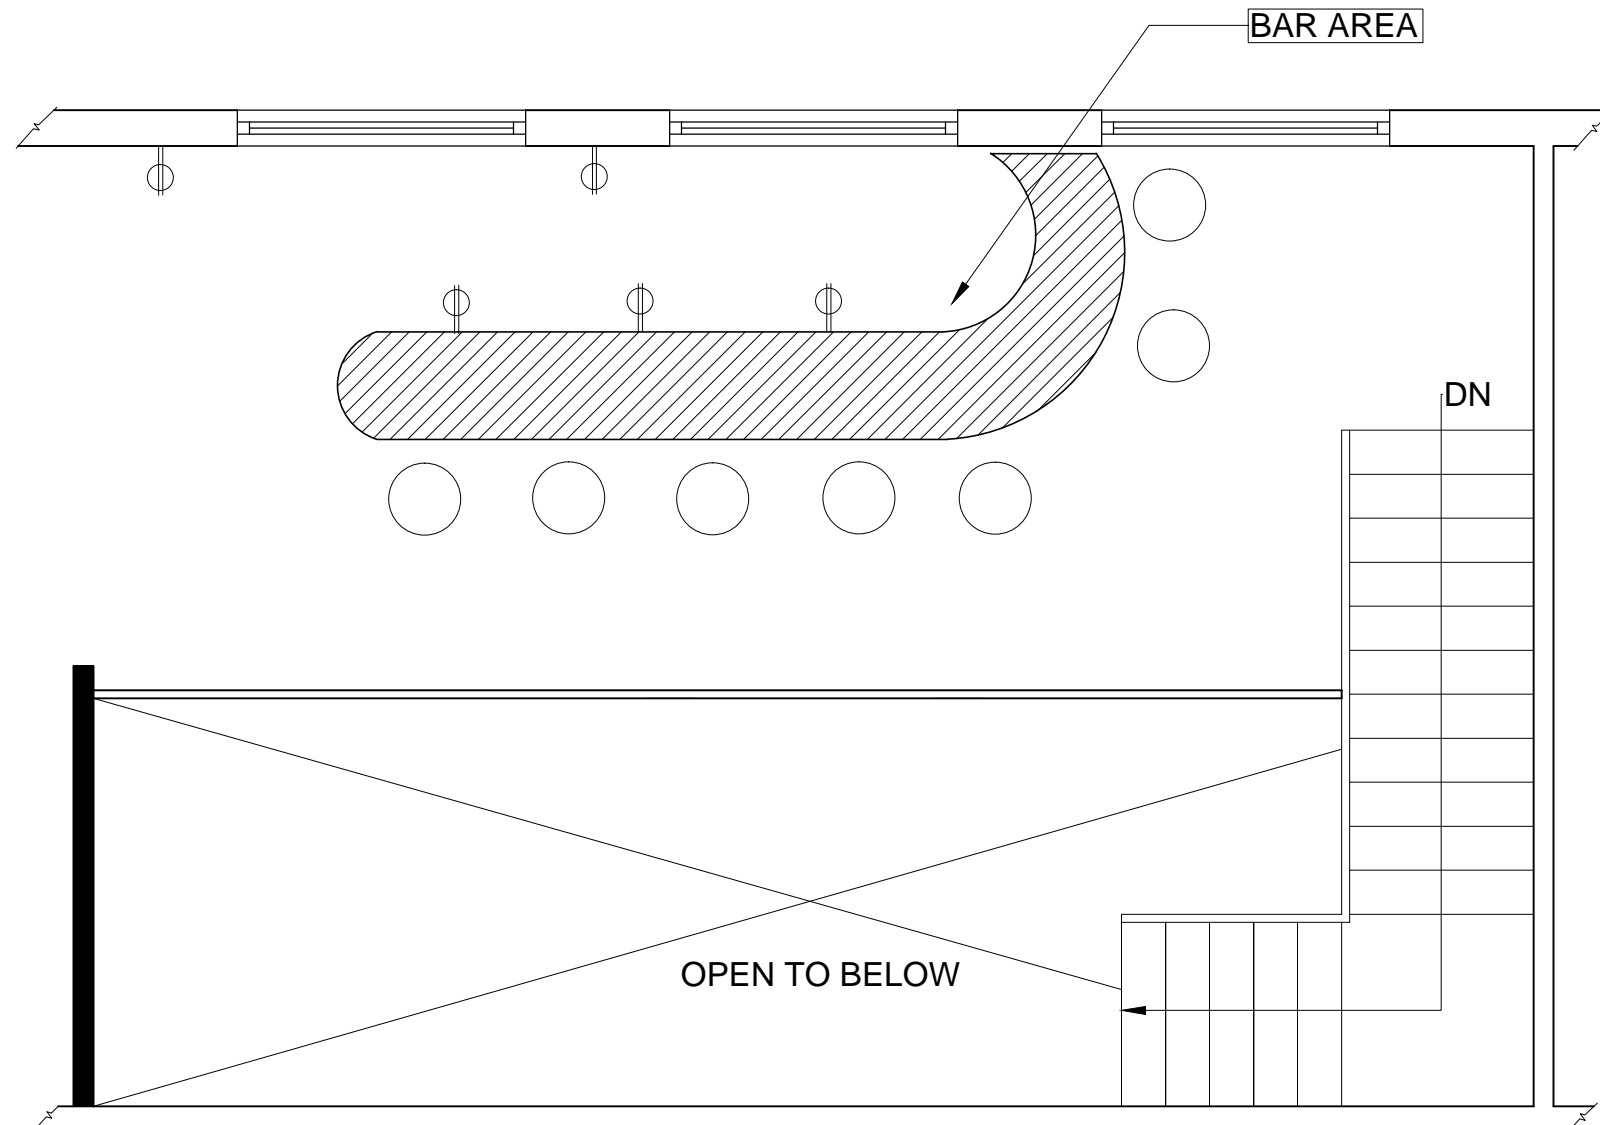

① POWER AND TELECOM PLAN 2ND FLOOR
 SCALE: 0'- $\frac{1}{4}$ " = 1'-0"



General Notes

No.	Revision/Issue	Date

Firm Name and Address
 BAYLEE
 VINCENT

Project Name and Address
 IDSN 2281
 RECEPTION

Project	Sheet
Date	A3.2
Scale	SEE DWG

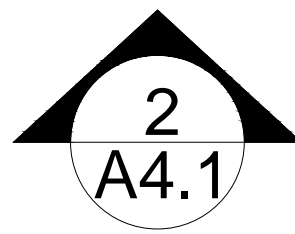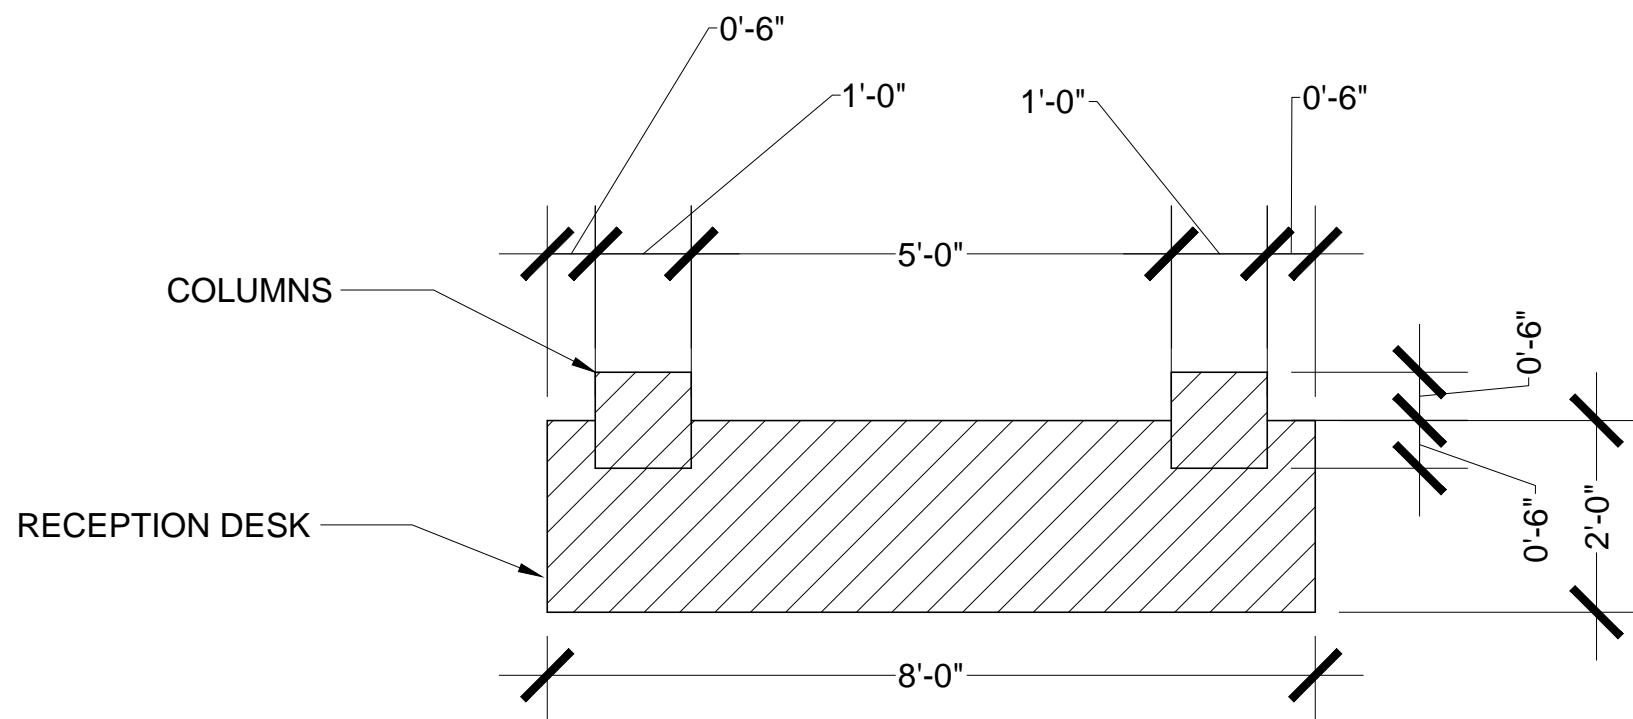

1 ENLARGED PLAN
 SCALE: 0'-1/2" = 1'-0"

General Notes


No.	Revision/Issue	Date

Firm Name and Address
 BAYLEE
 VINCENT

Project Name and Address
 IDSN 2281
 RECEPTION

Project	Sheet
Date	A4.1
Scale	SEE DWG

1
A4.3

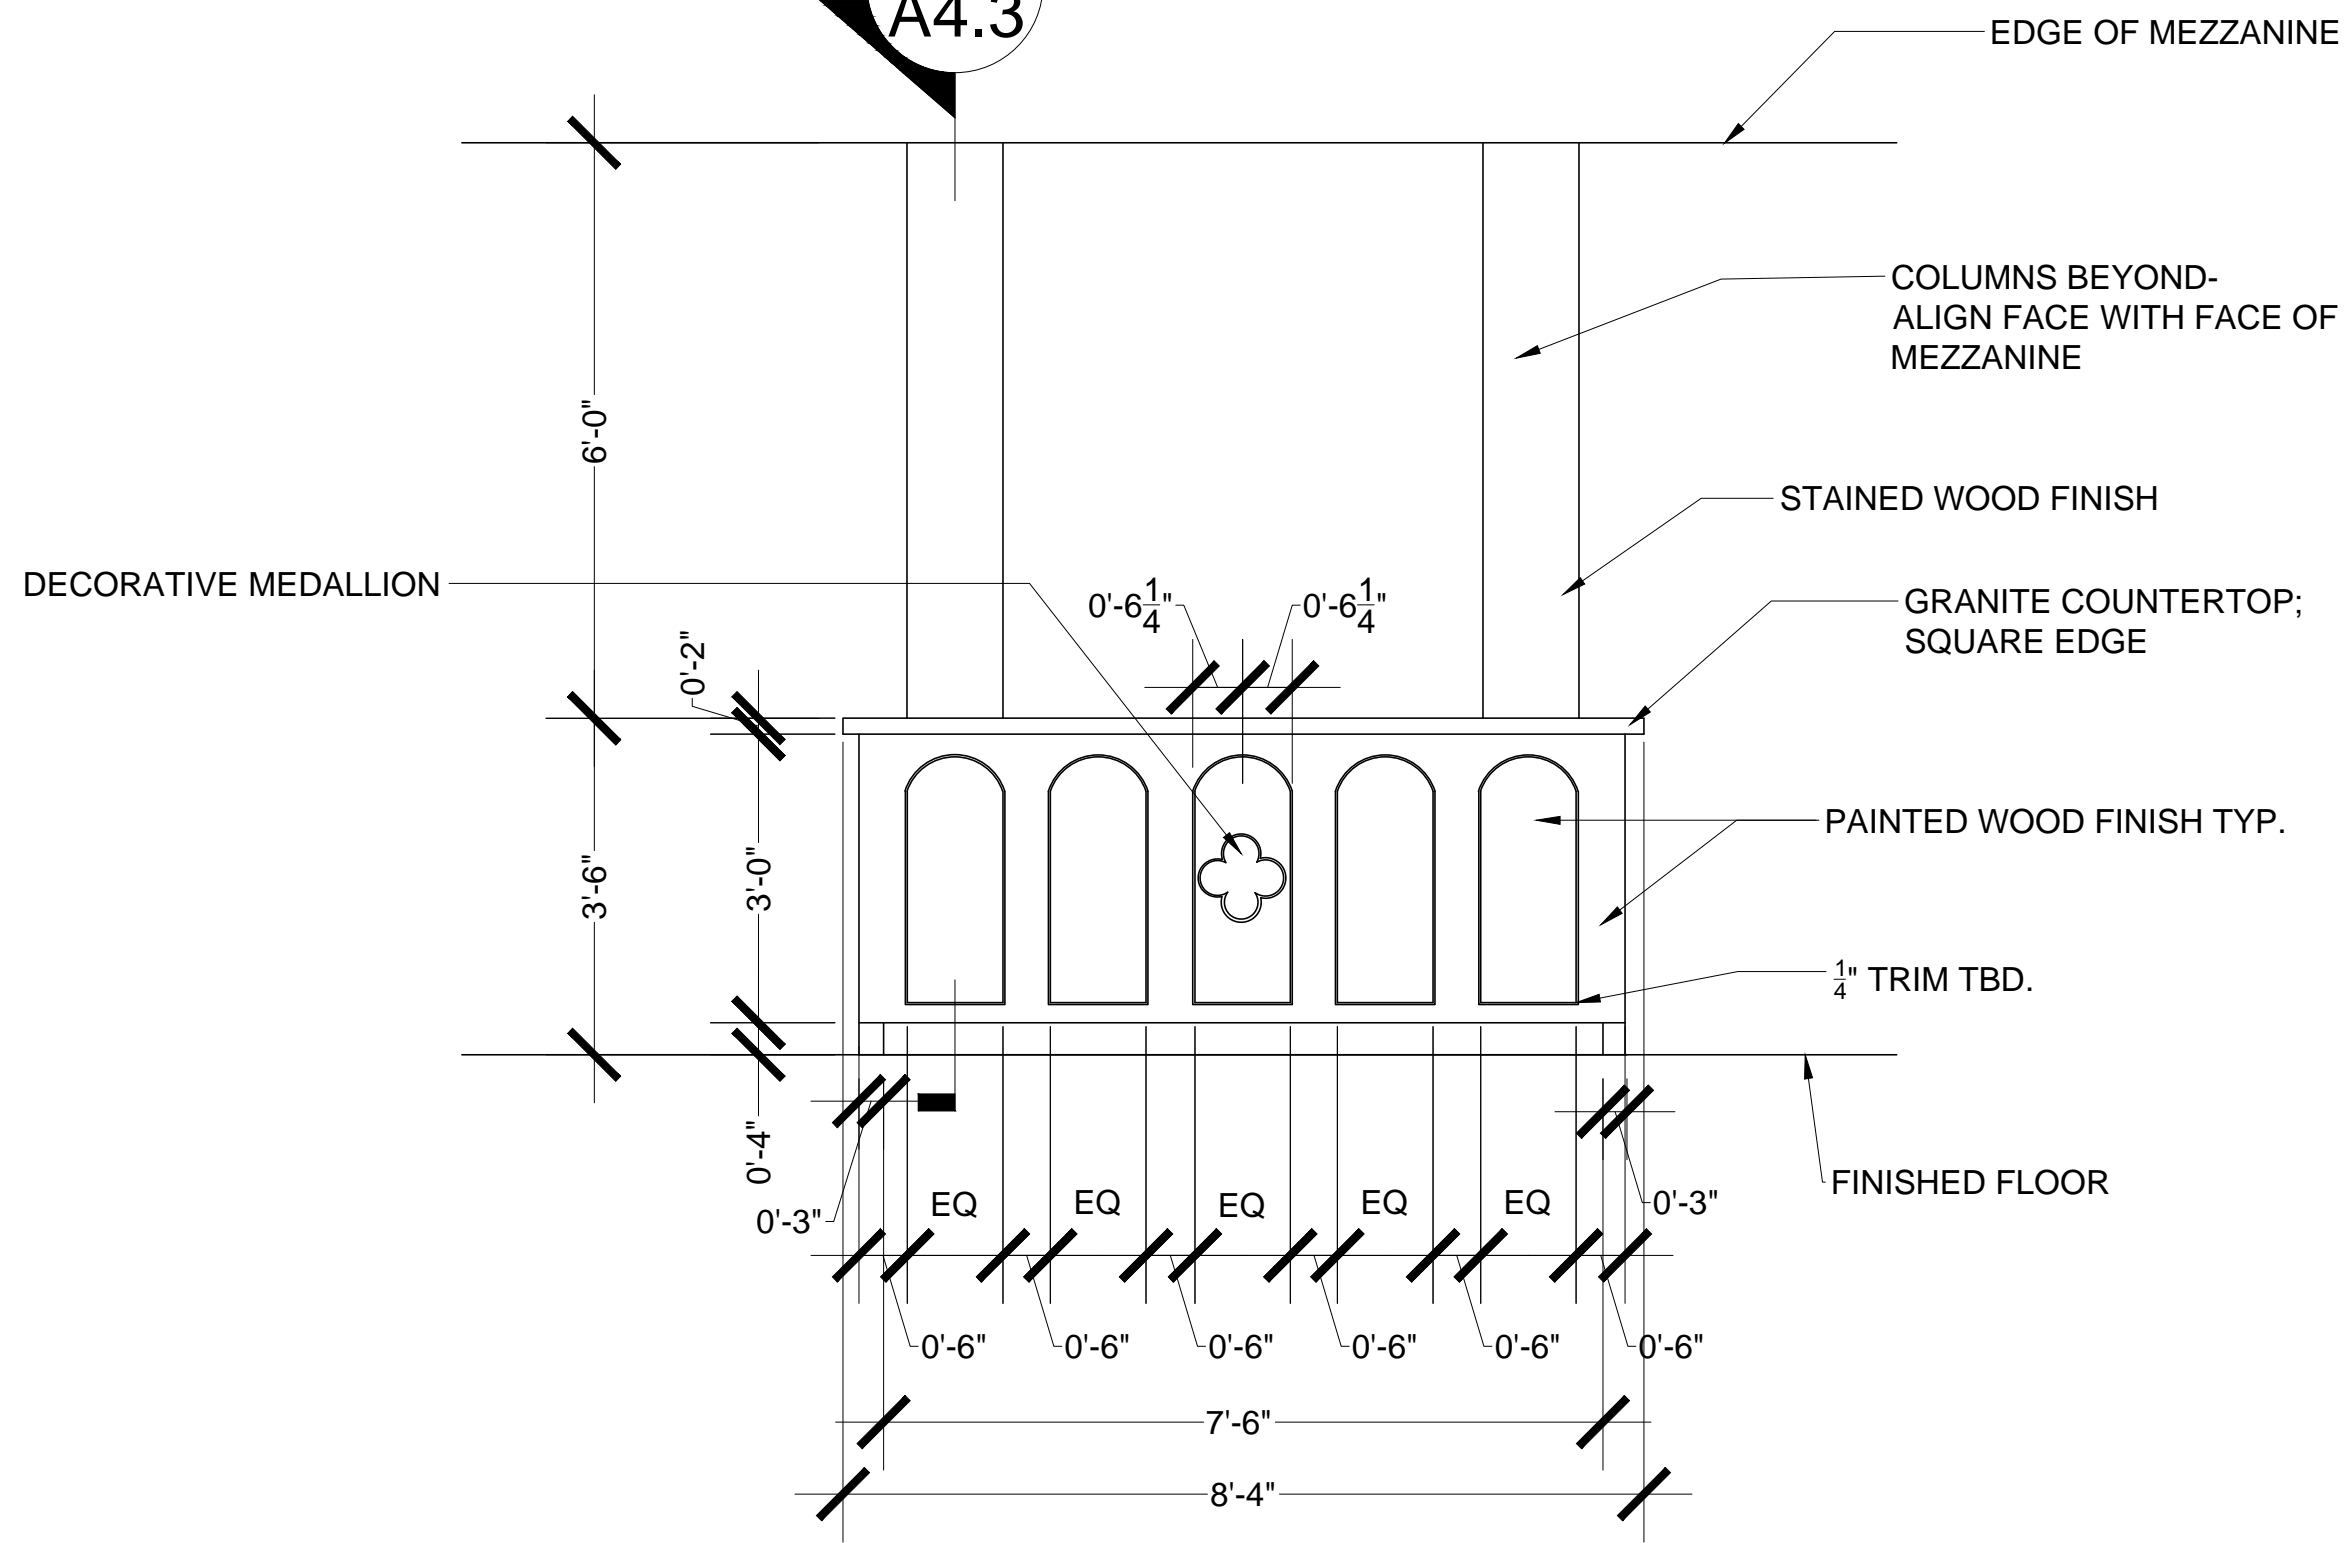

1 ELEVATION PLAN- FRONT VIEW
SCALE: 0'-1/2" = 1'-0"


General Notes

No.	Revision/Issue	Date

Firm Name and Address
BAYLEE
VINCENT

Project Name and Address
IDSN 2281
RECEPTION

Project	Sheet
Date	A4.2
Scale	SEE DWG

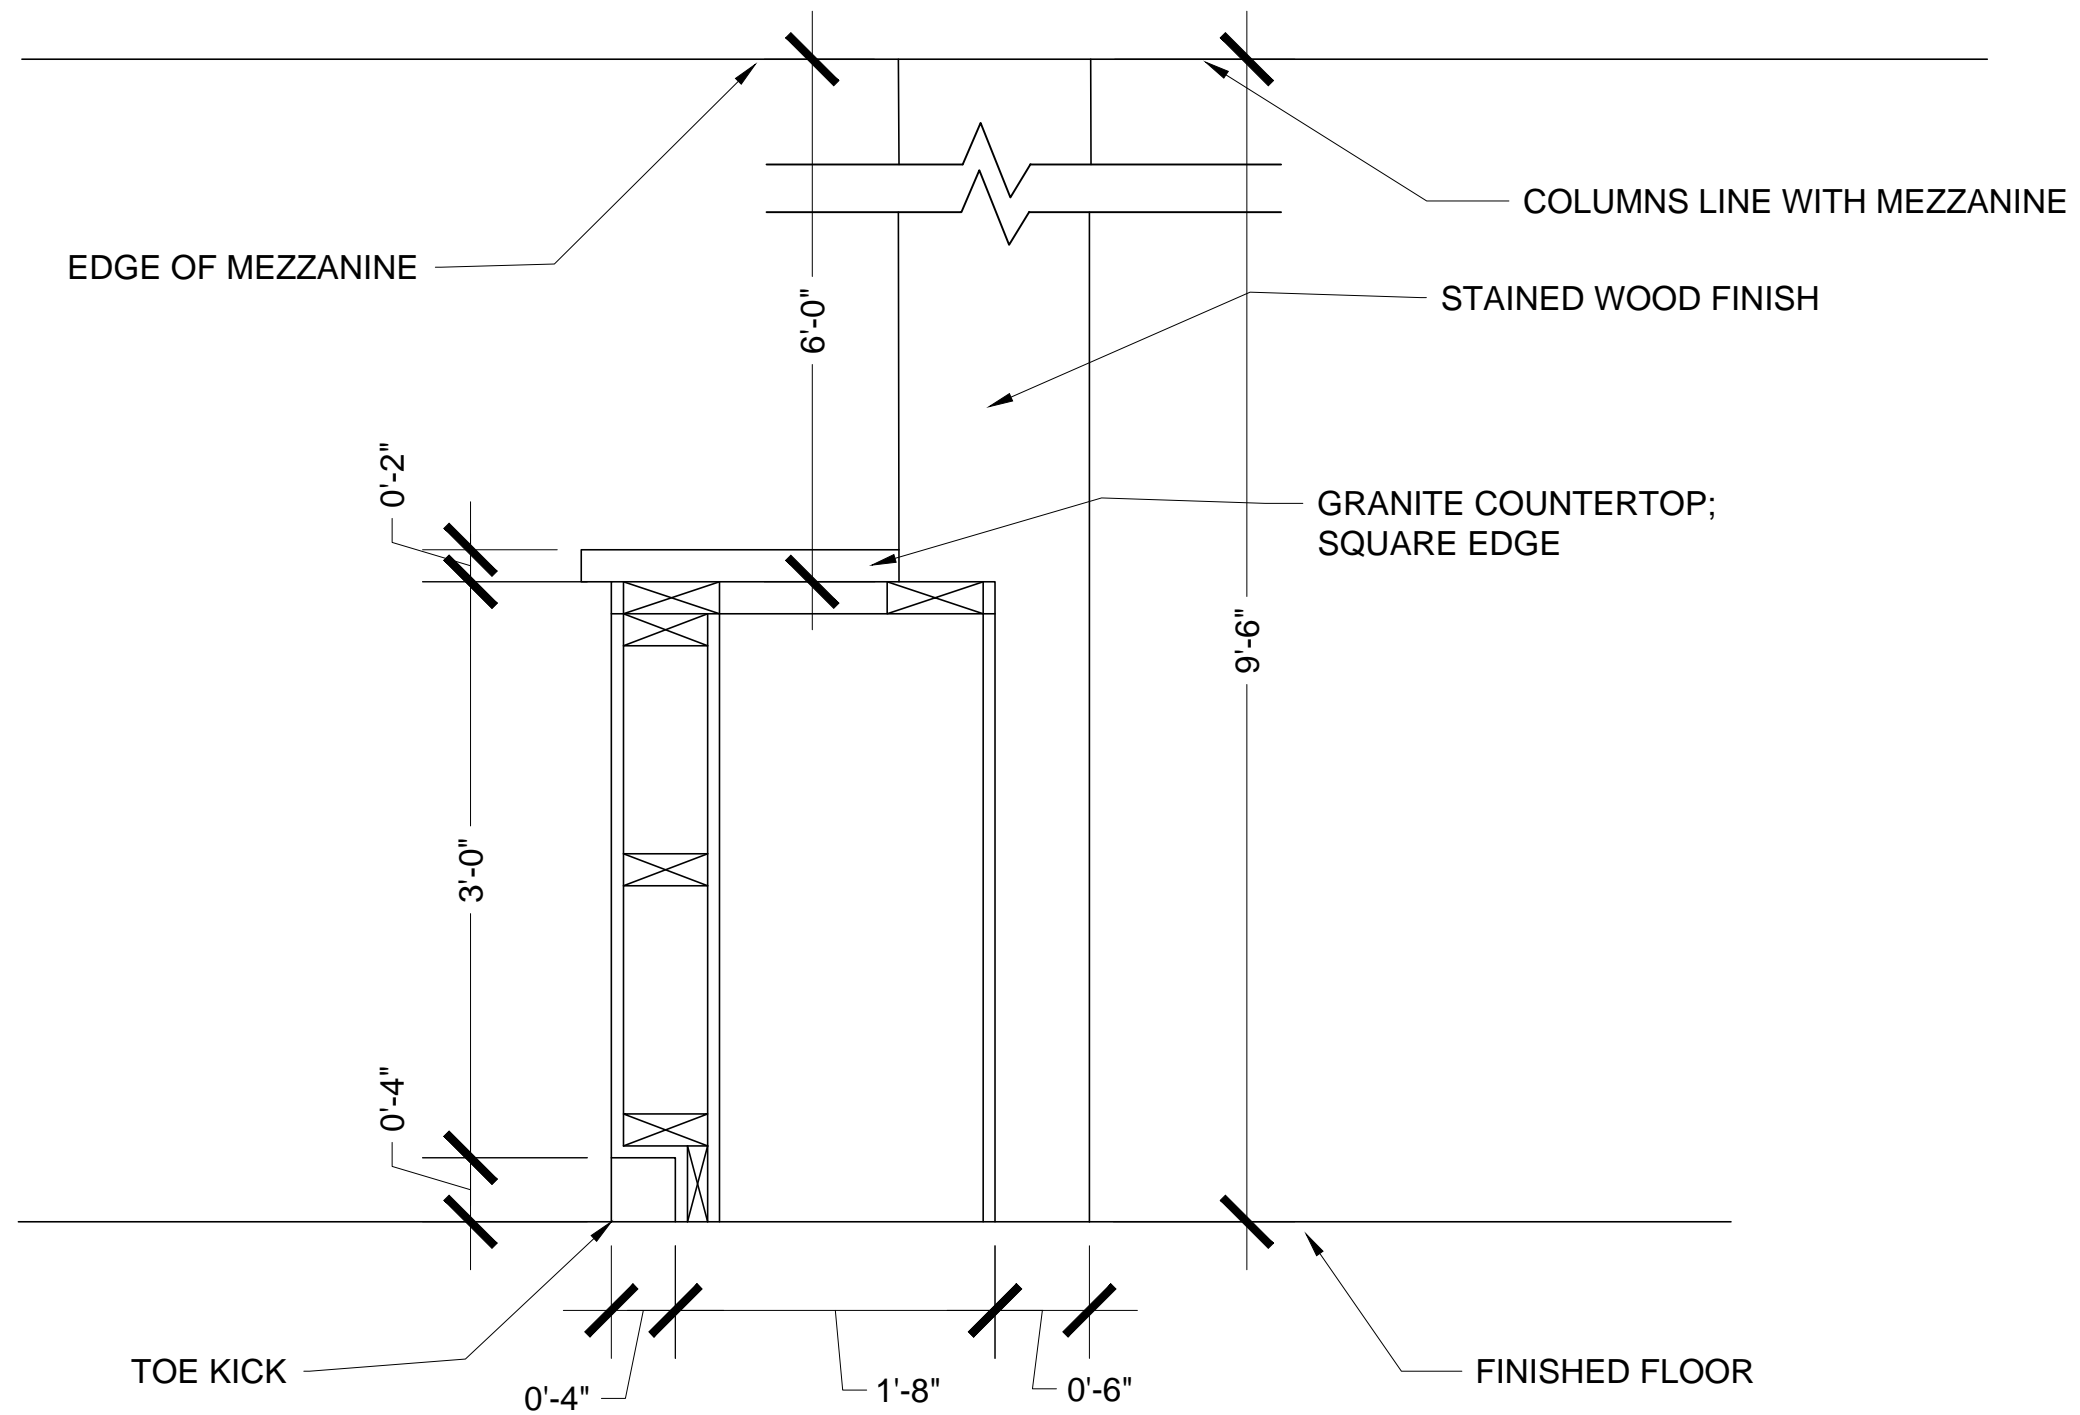

① SECTION PLAN
SCALE: 0'-1" = 1'-0"


General Notes

No.	Revision/Issue	Date

Firm Name and Address
**BAYLEE
 VINCENT**

Project Name and Address
 IDSN 2281
 RECEPTION

Project	Sheet
Date	A4.3
Scale	SEE DWG

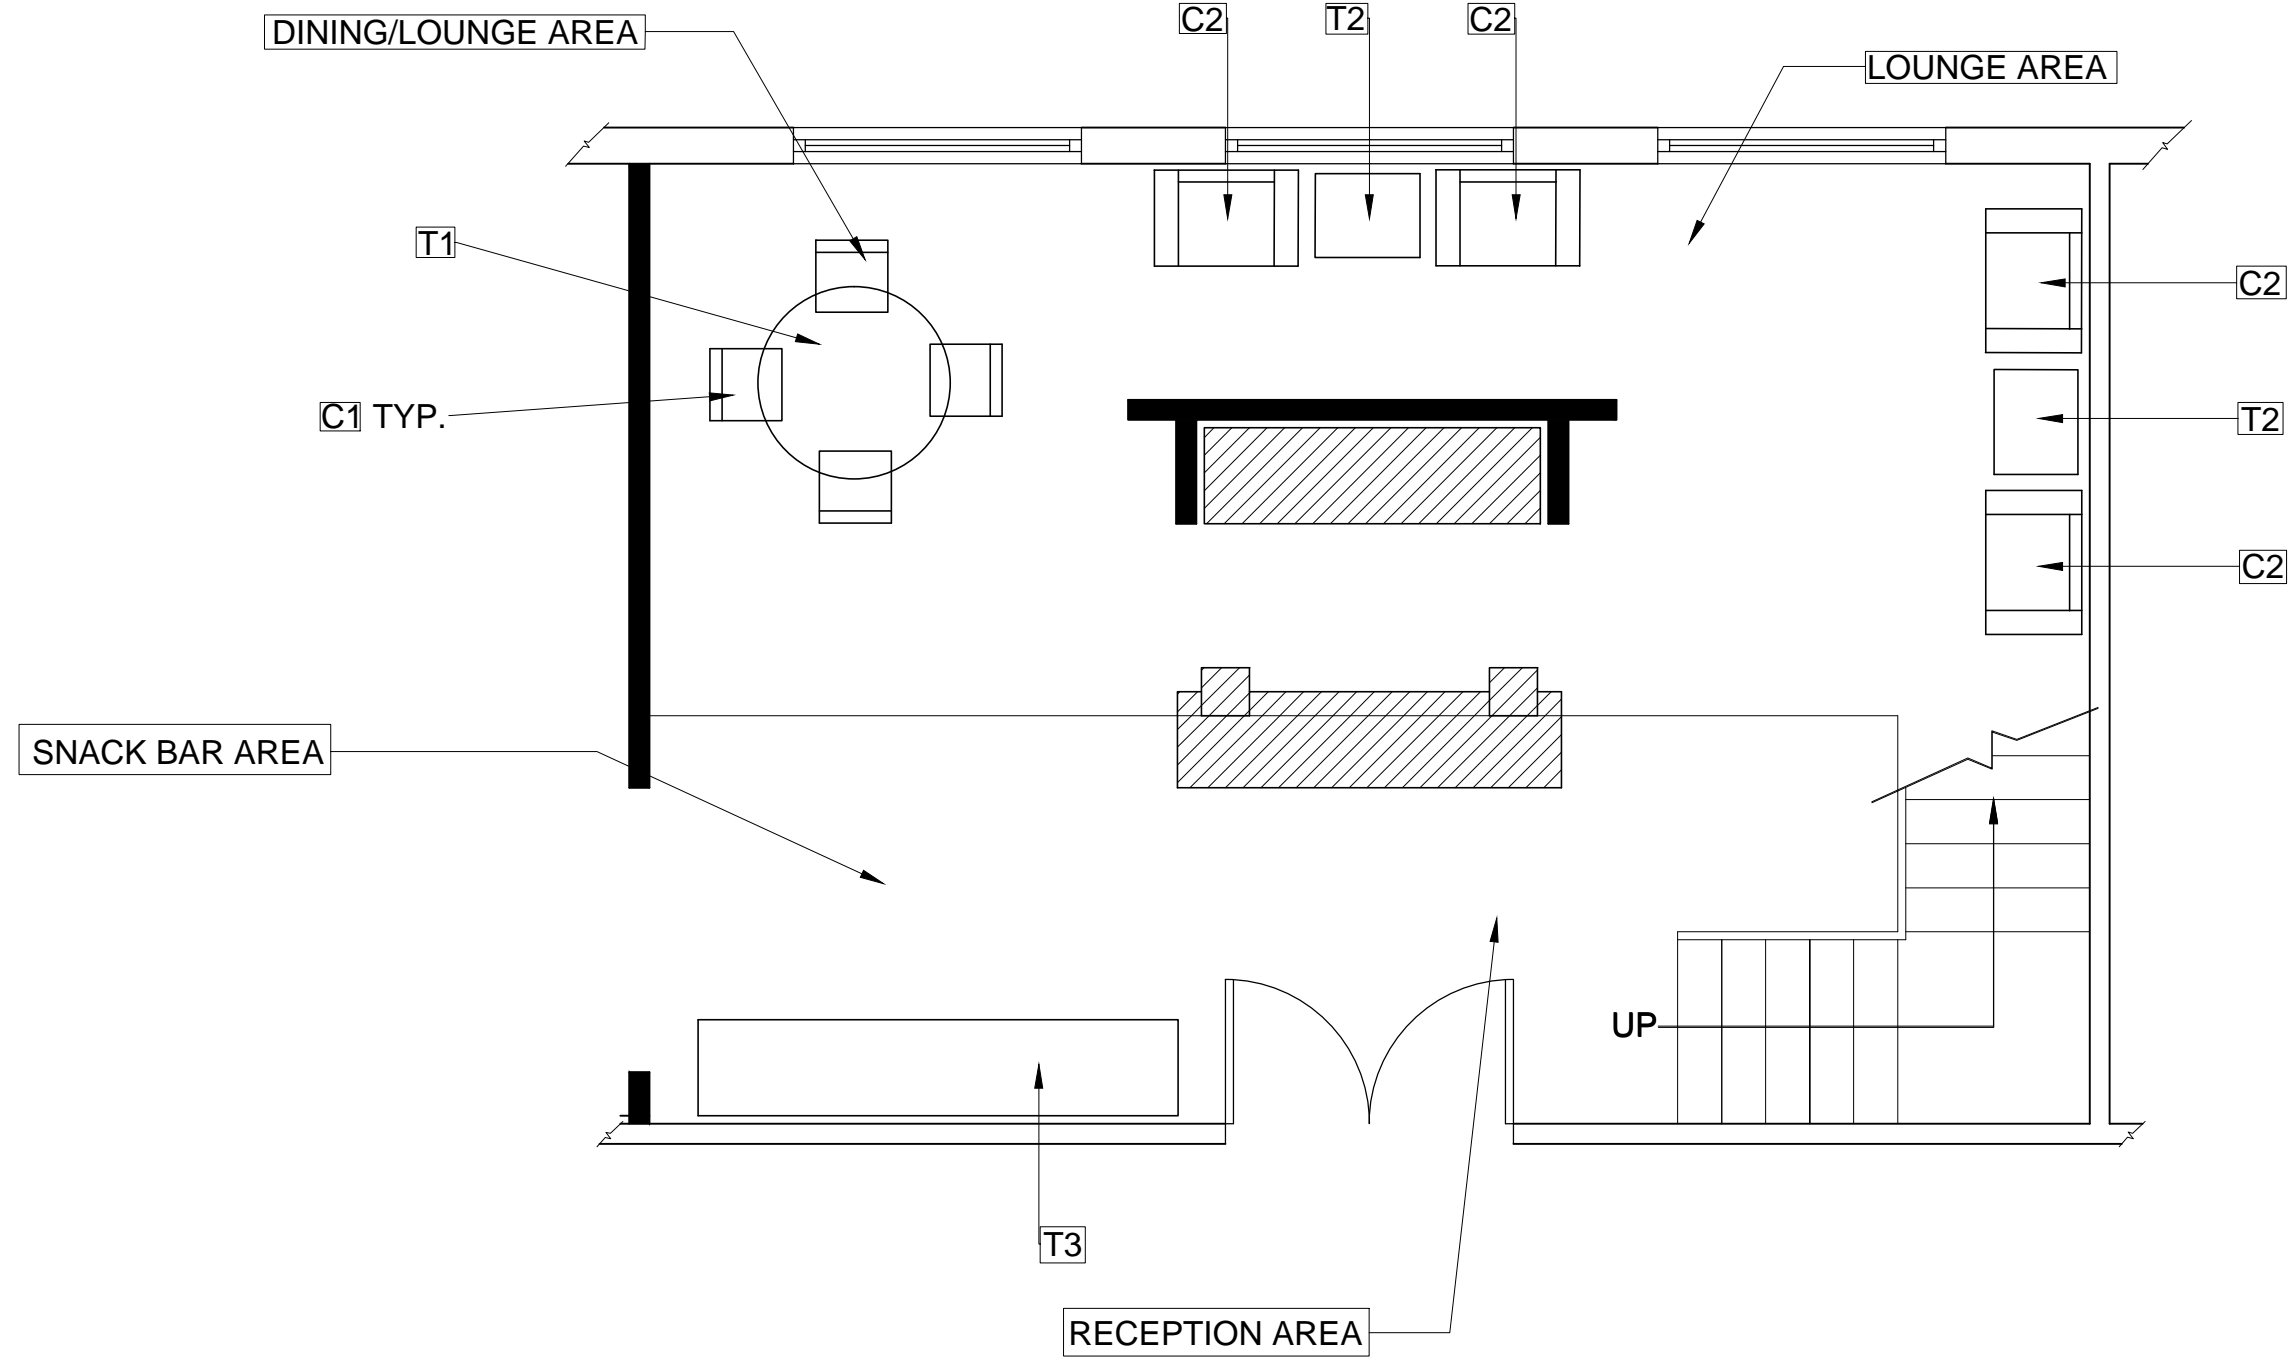

① FURNITURE PLAN 1ST FLOOR
 SCALE: 0'-1/4" = 1'-0"


General Notes

No.	Revision/Issue	Date

Firm Name and Address
 BAYLEE
 VINCENT

Project Name and Address
 IDSN 2281
 RECEPTION

Project	Sheet
Date	F1.1
Scale	SEE DWG

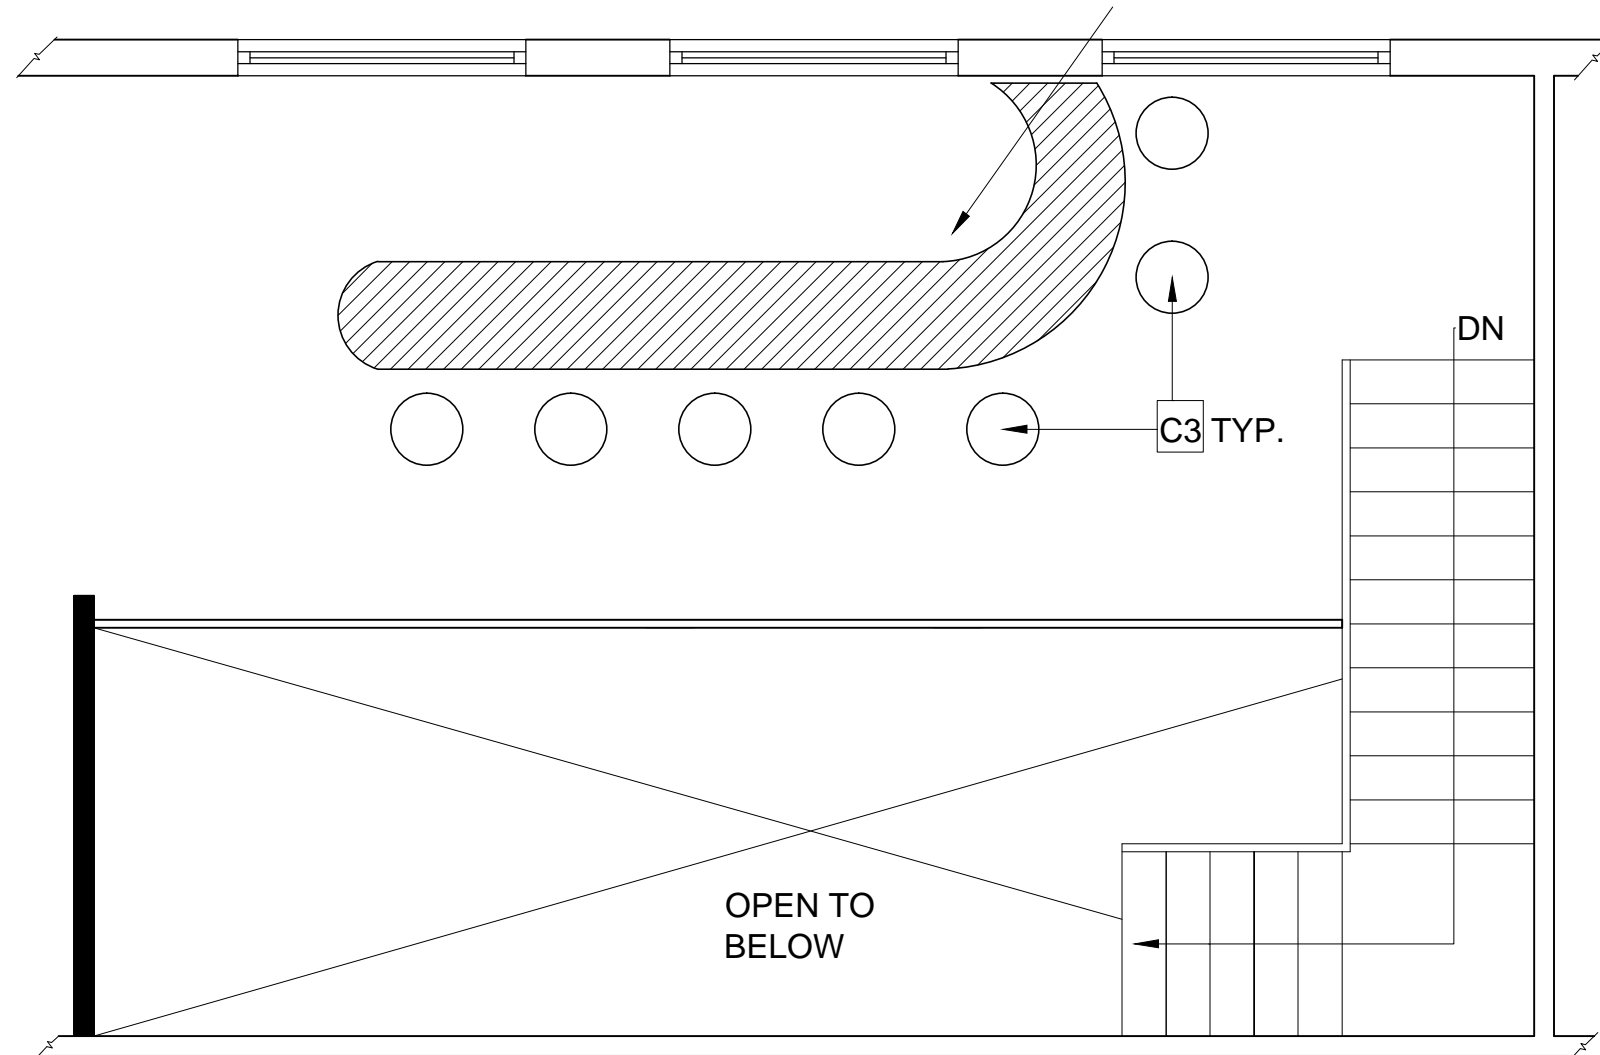

① FURNITURE PLAN 2ND FLOOR
 SCALE: 0'- $\frac{1}{4}$ " = 1'-0"

General Notes

No.	Revision/Issue	Date

Firm Name and Address
 BAYLEE
 VINCENT

Project Name and Address
 IDSN 2281
 RECEPTION

Project	Sheet
Date	F1.2
Scale	SEE DWG