

SHARED TENNANT OFFICE SPACE


Co-Working Business Model

Edgeworth Building
Richmond, Virginia
Third Floor





PORTFOLIO 3


James Higgins
IDSN 3600
East Carolina University




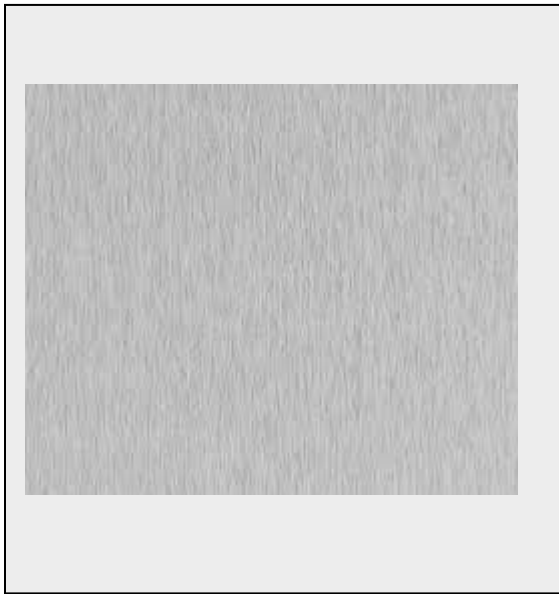



Materials and Finishes

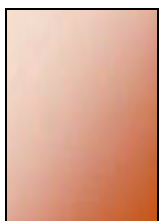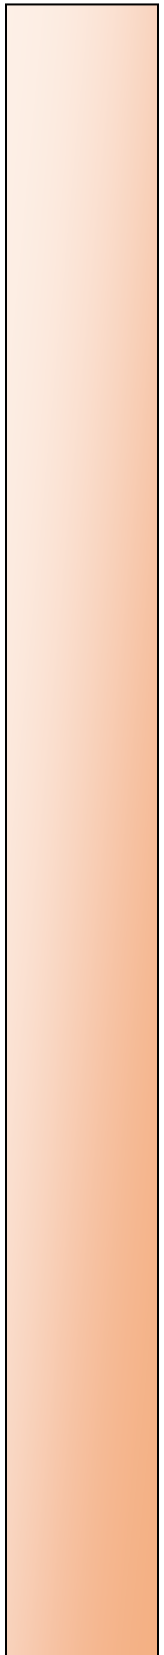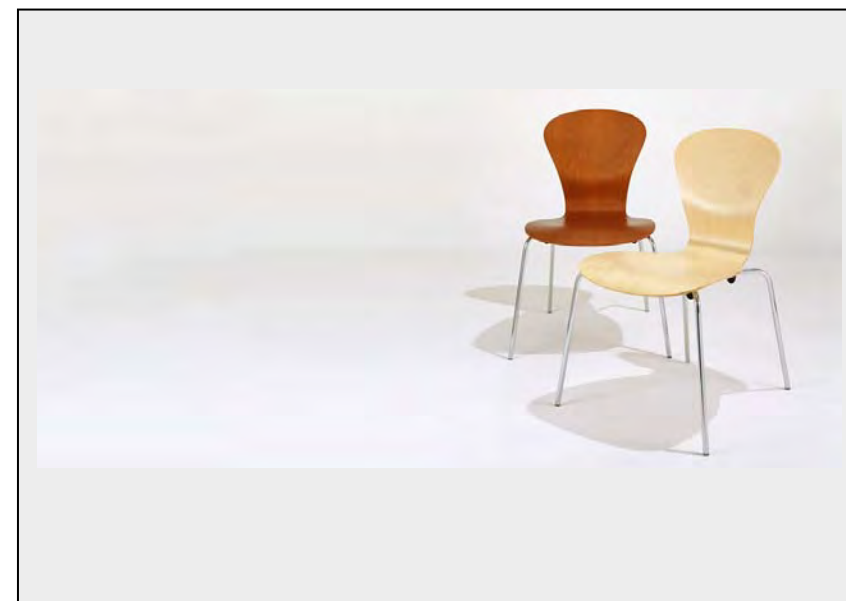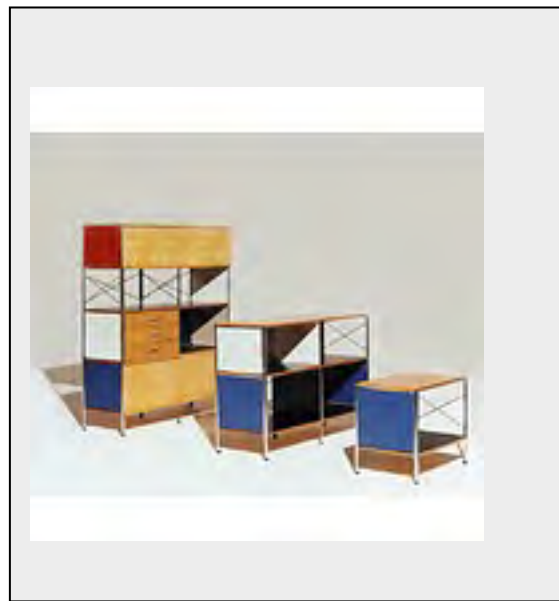

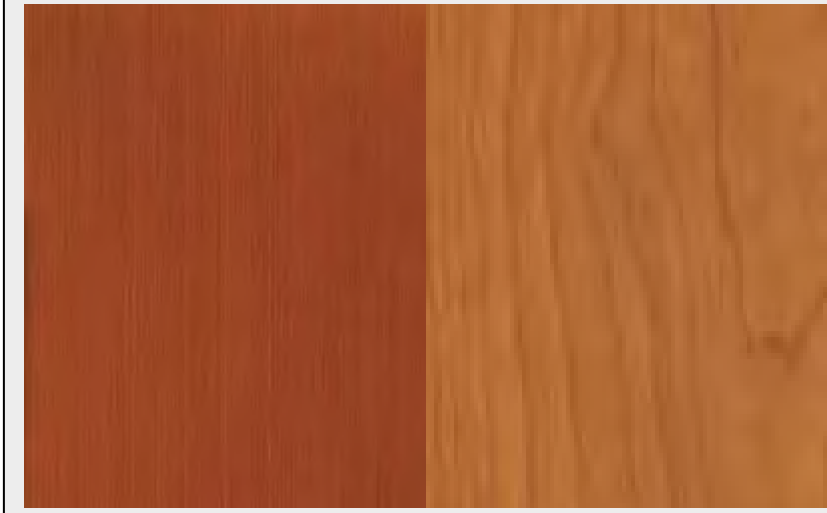


Materials and Finishes

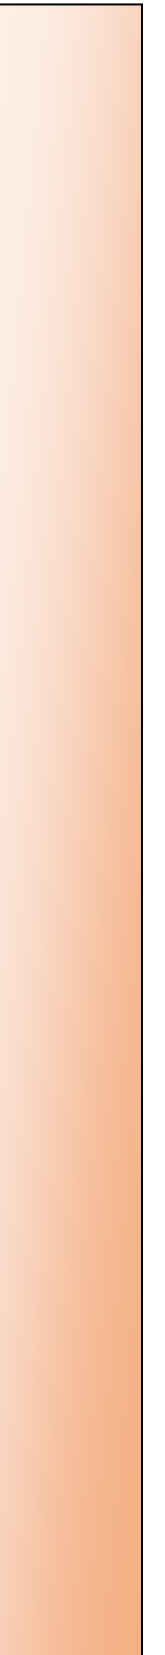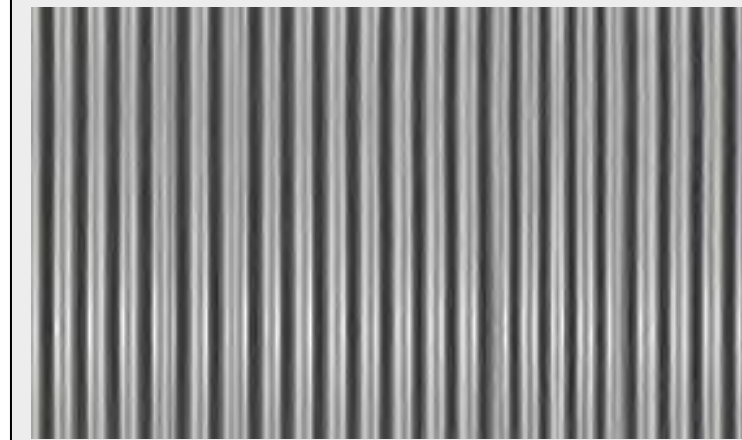

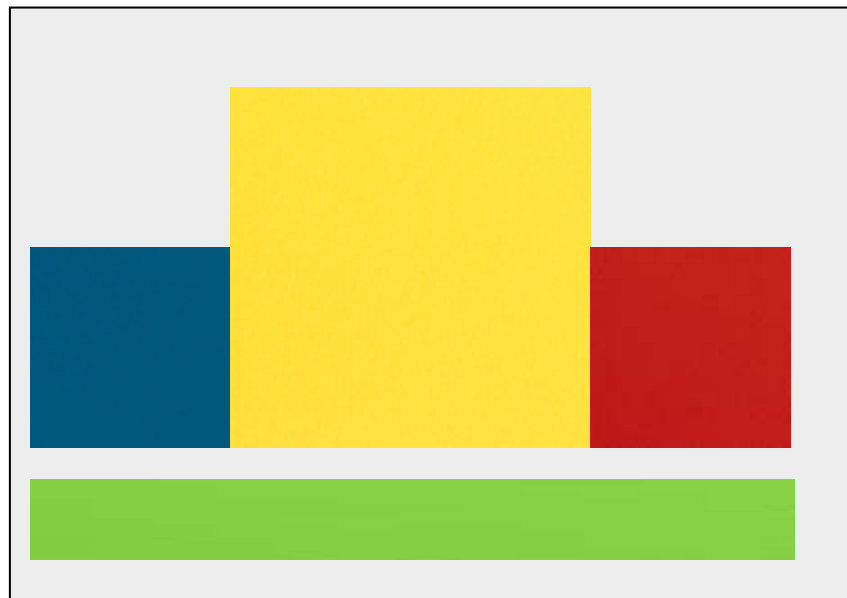


Materials and Finishes

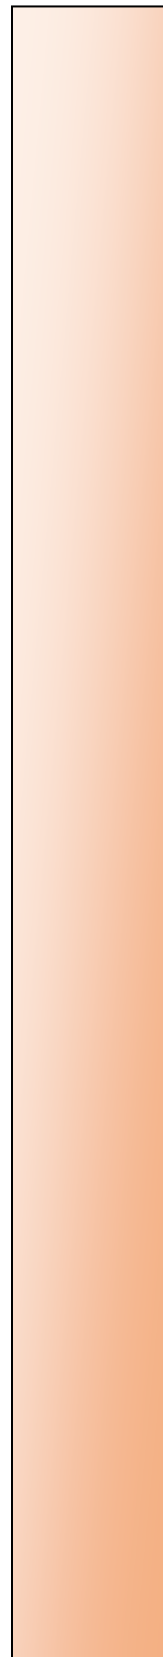





Conference Room

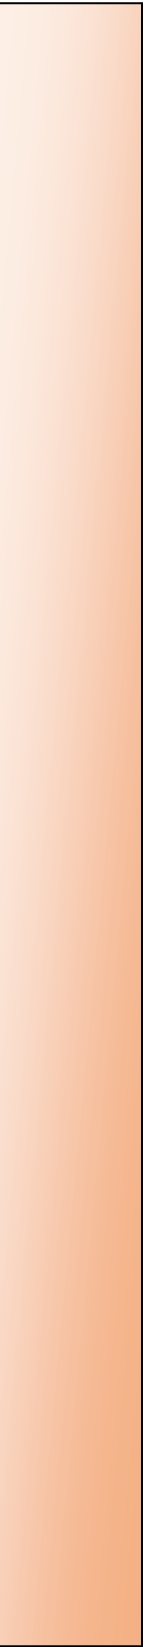




Main Entry

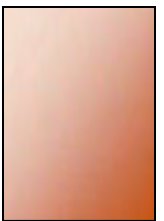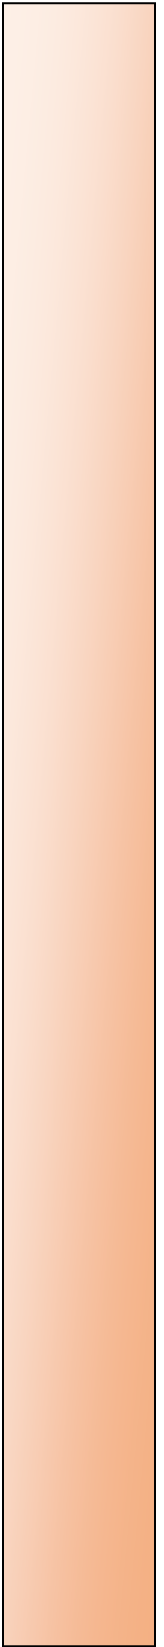






Lunch Area

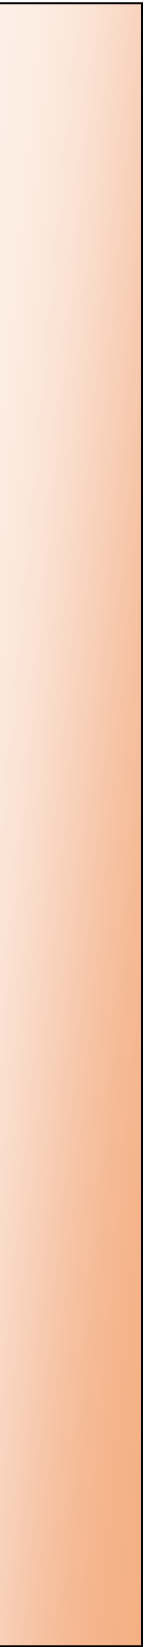





Reception

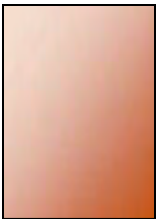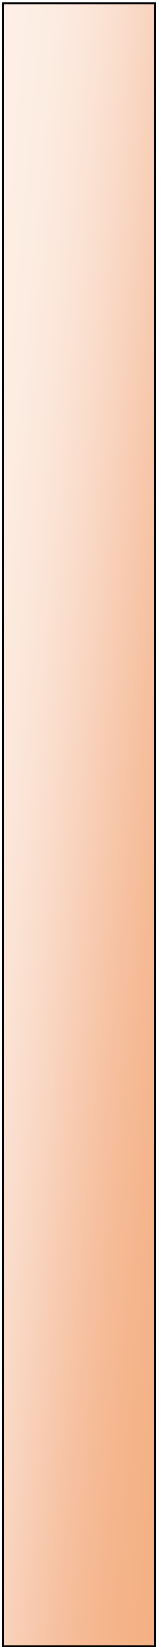


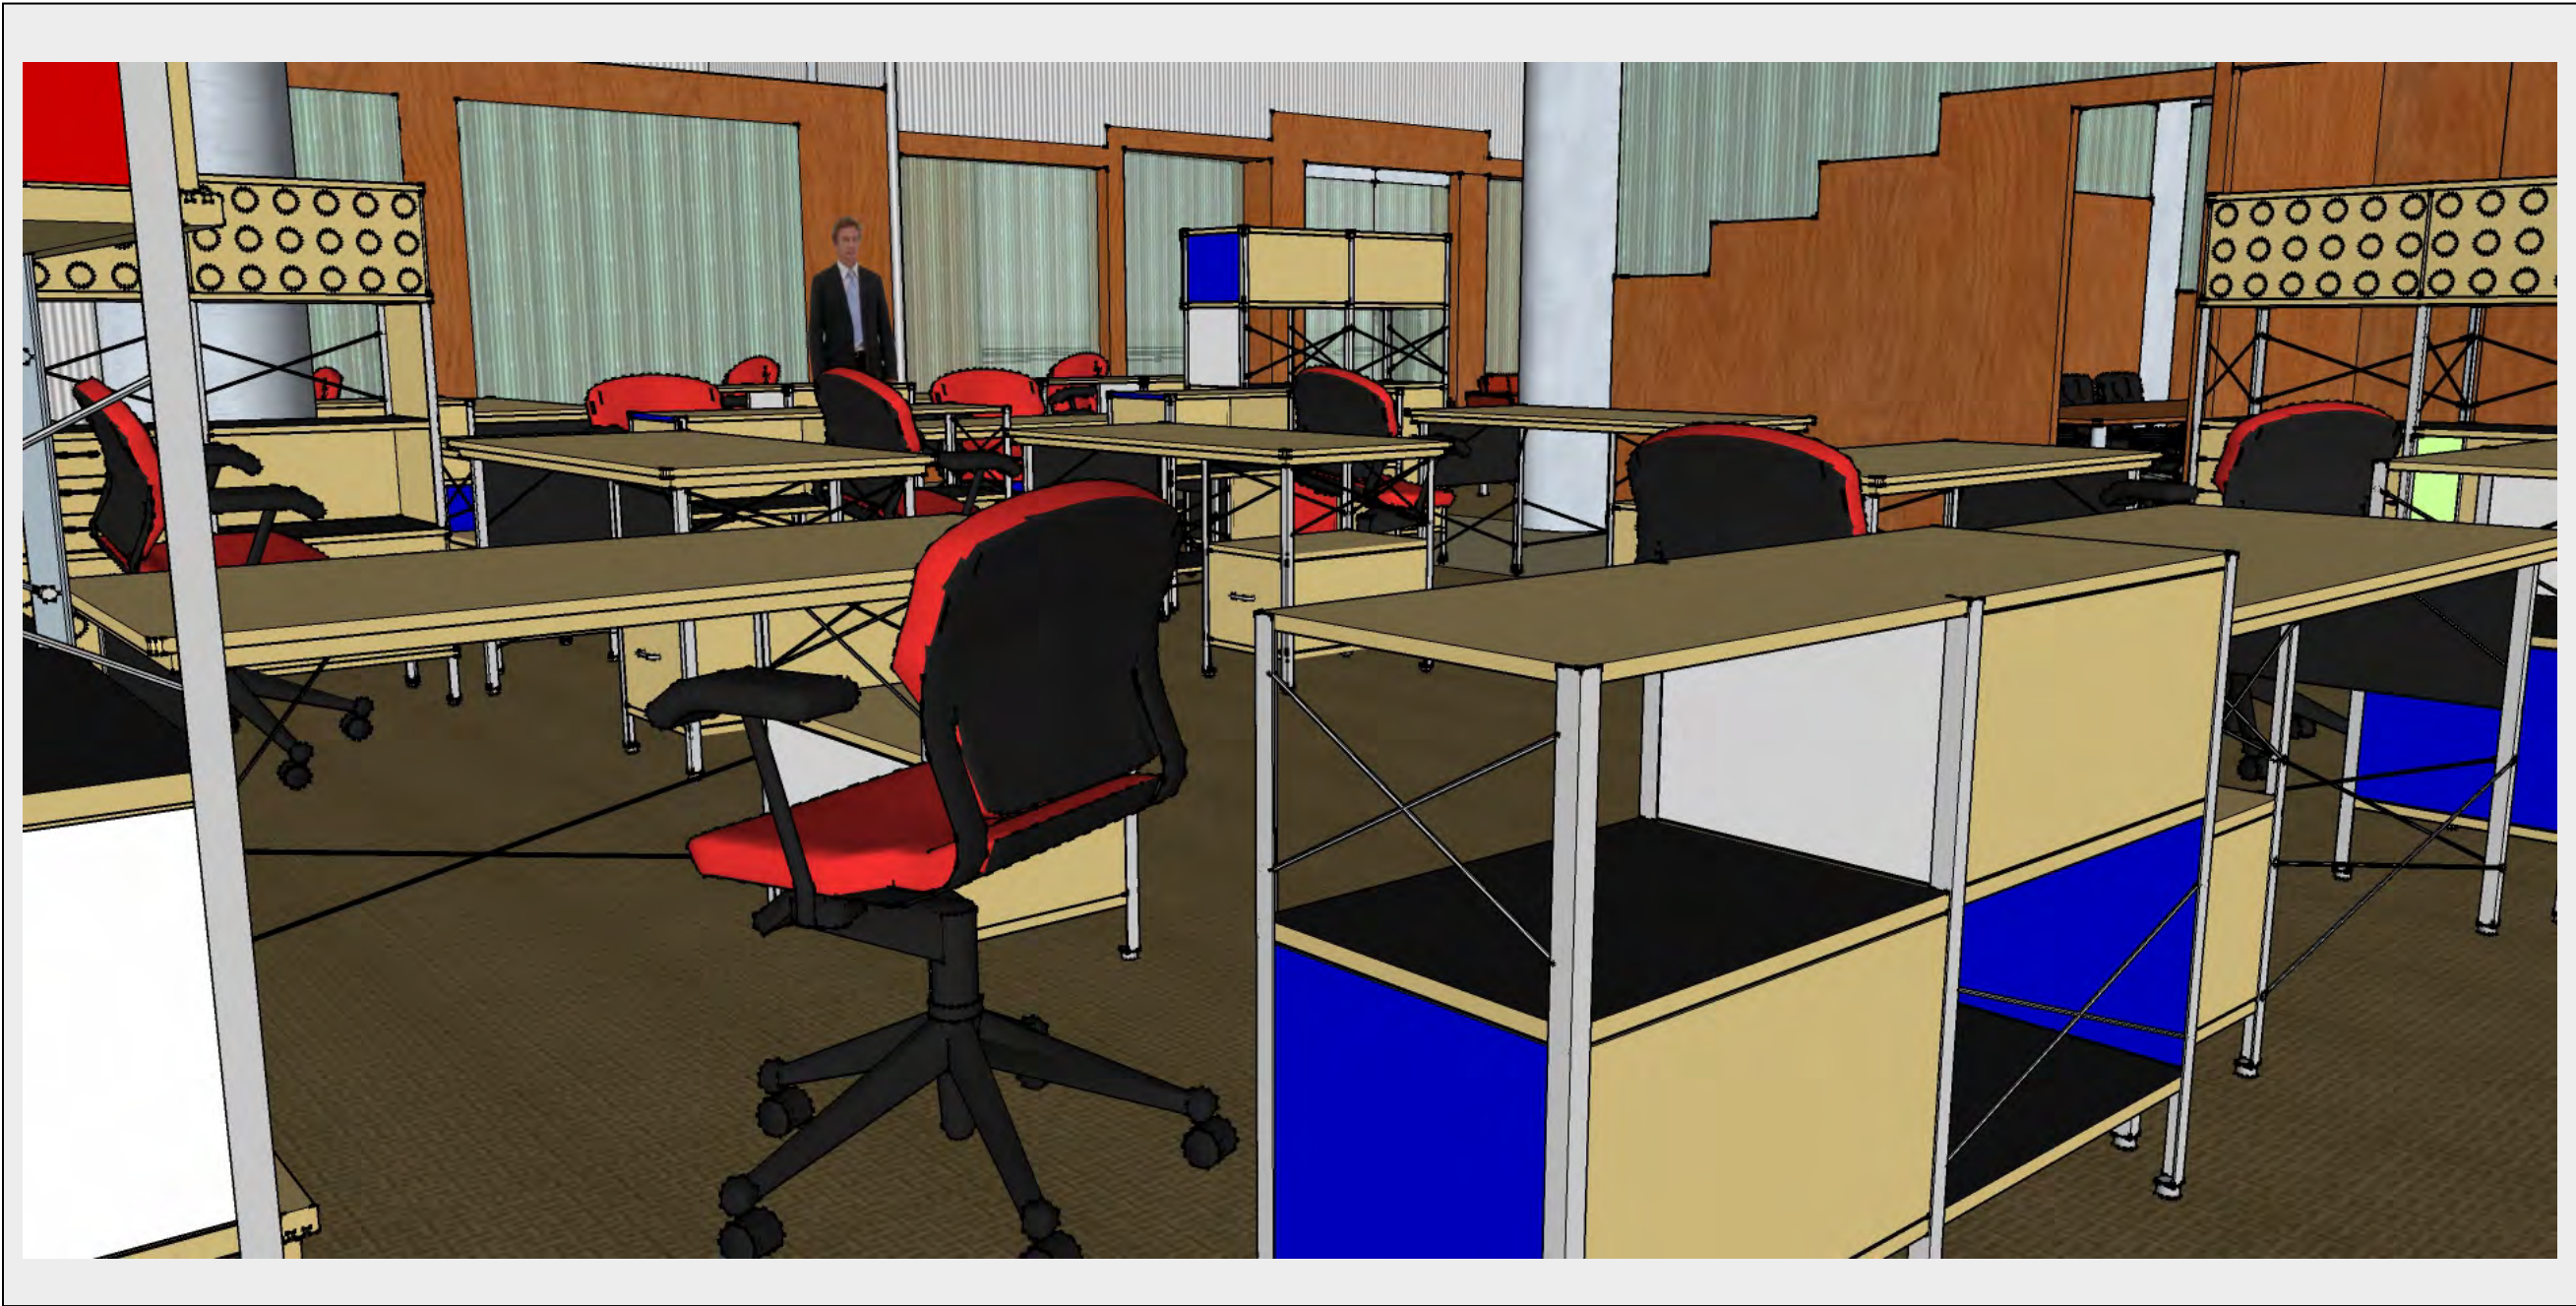


Workstations

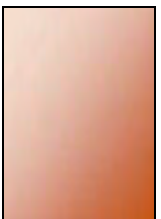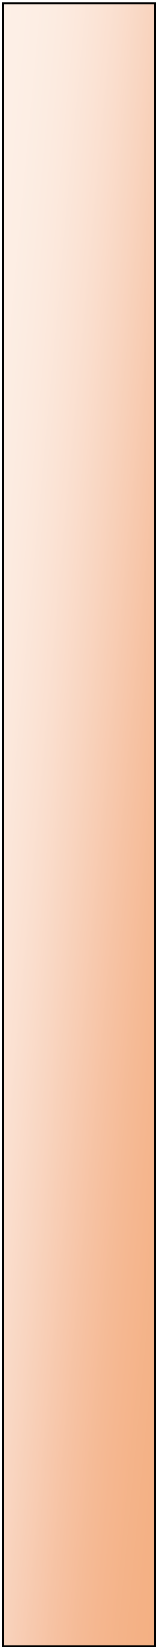






Workstations

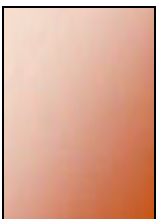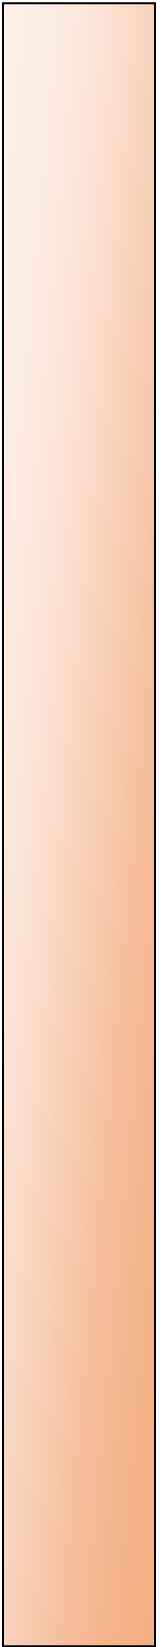






Conference Room and Collaborative Work Area

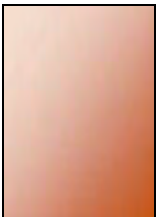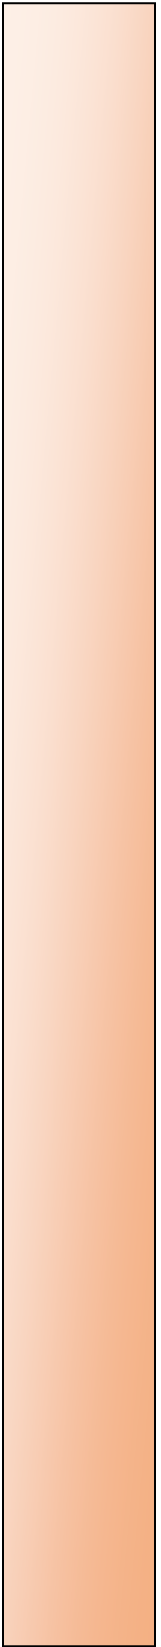

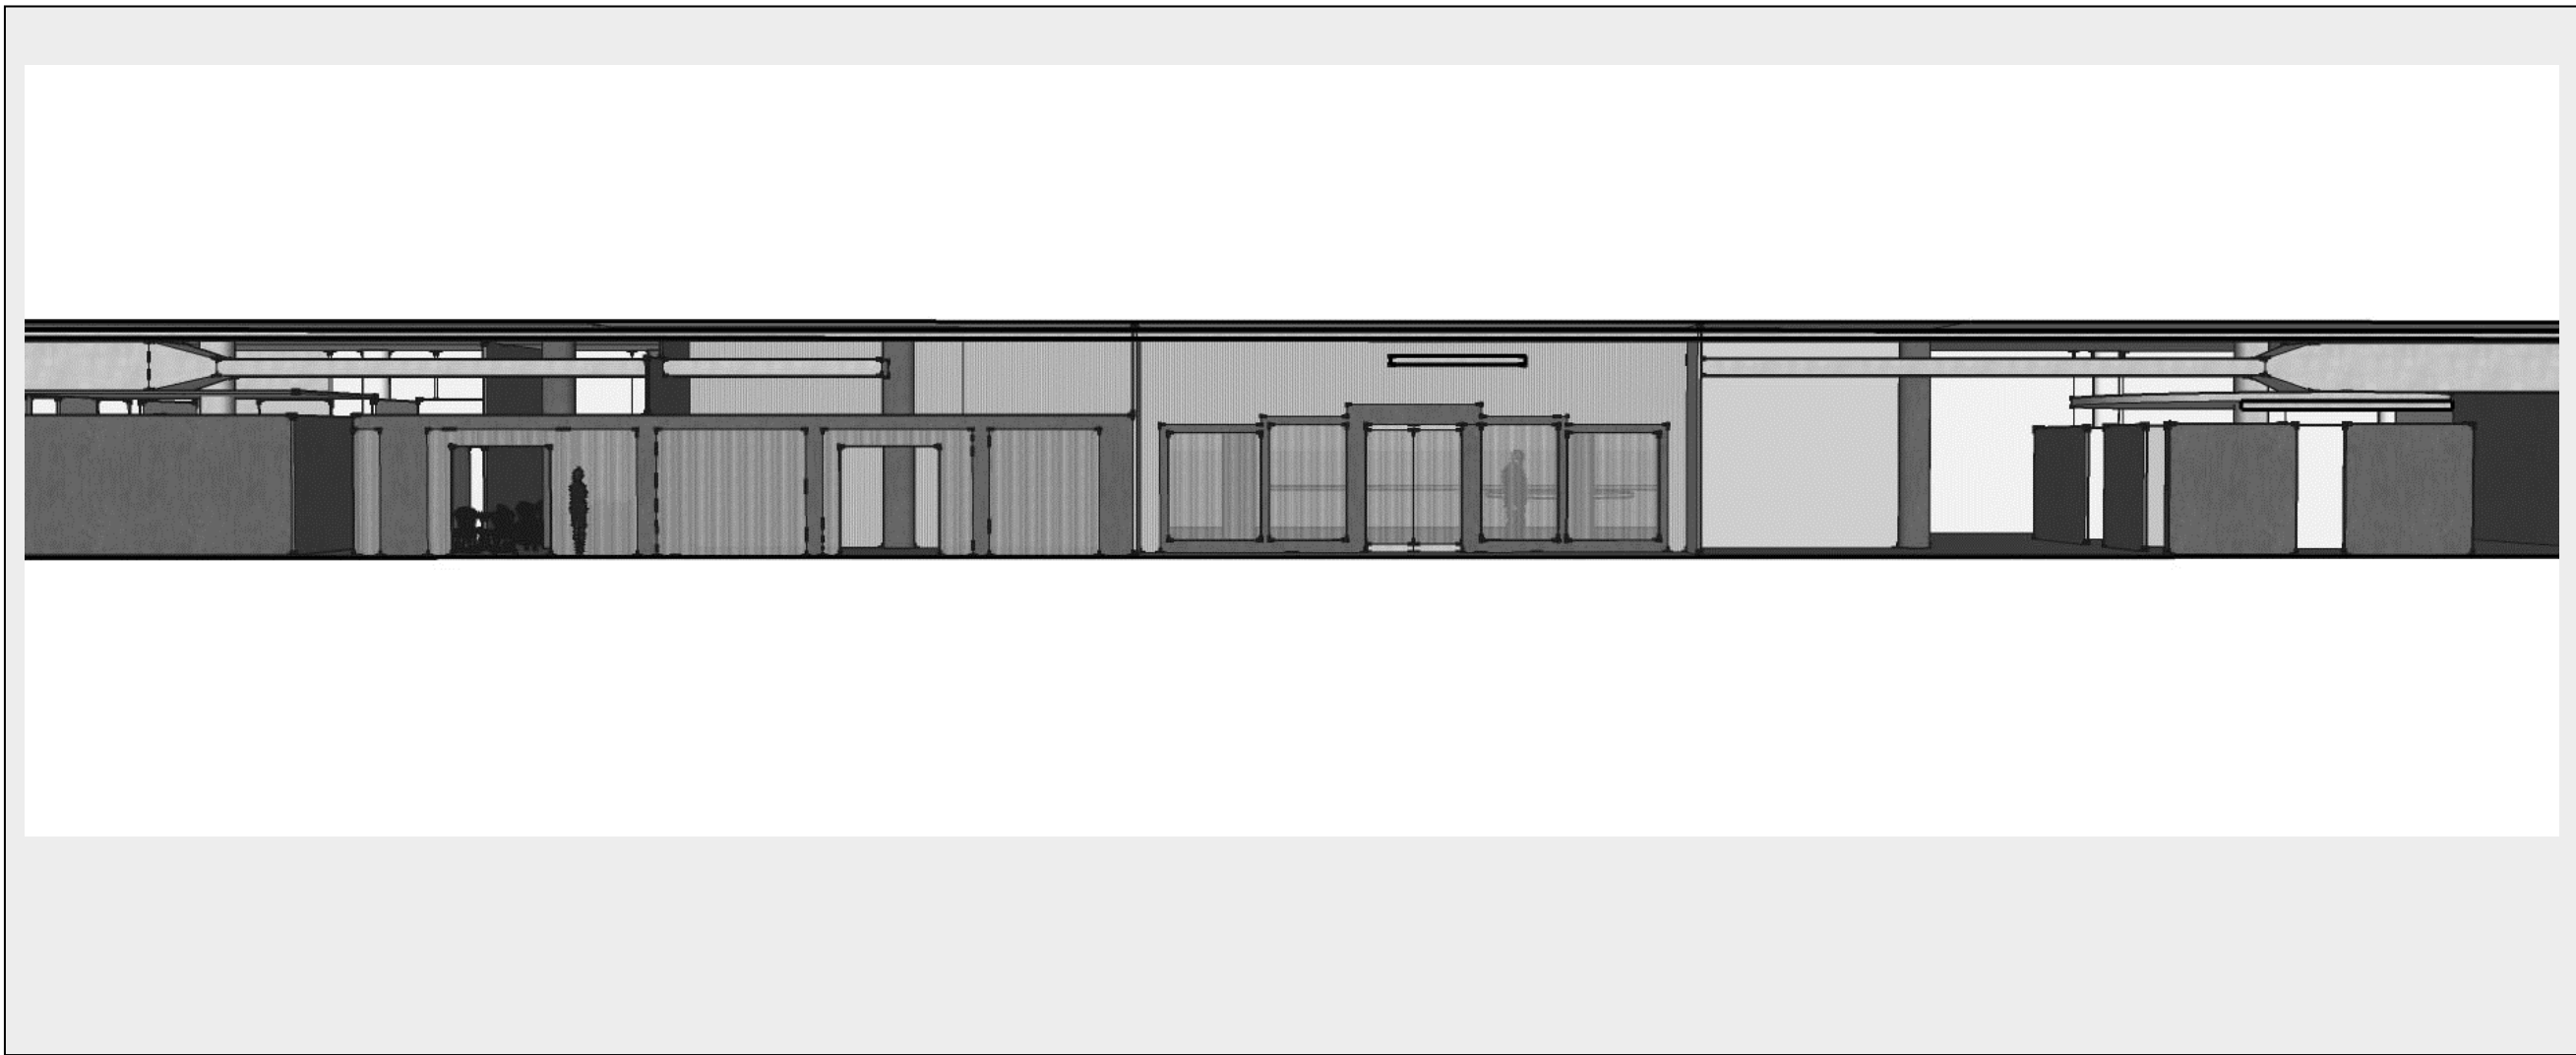
 

 


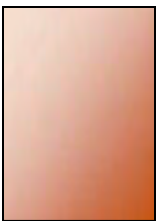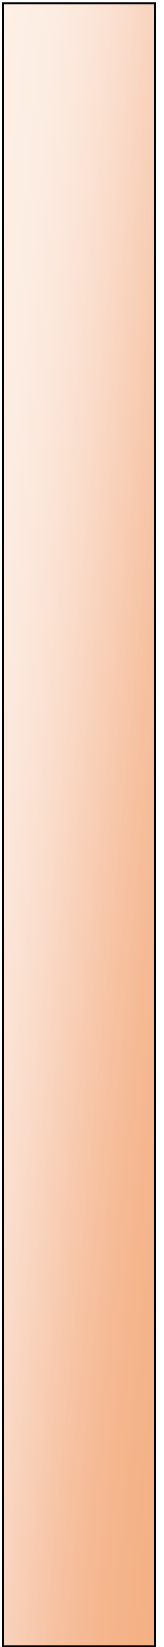


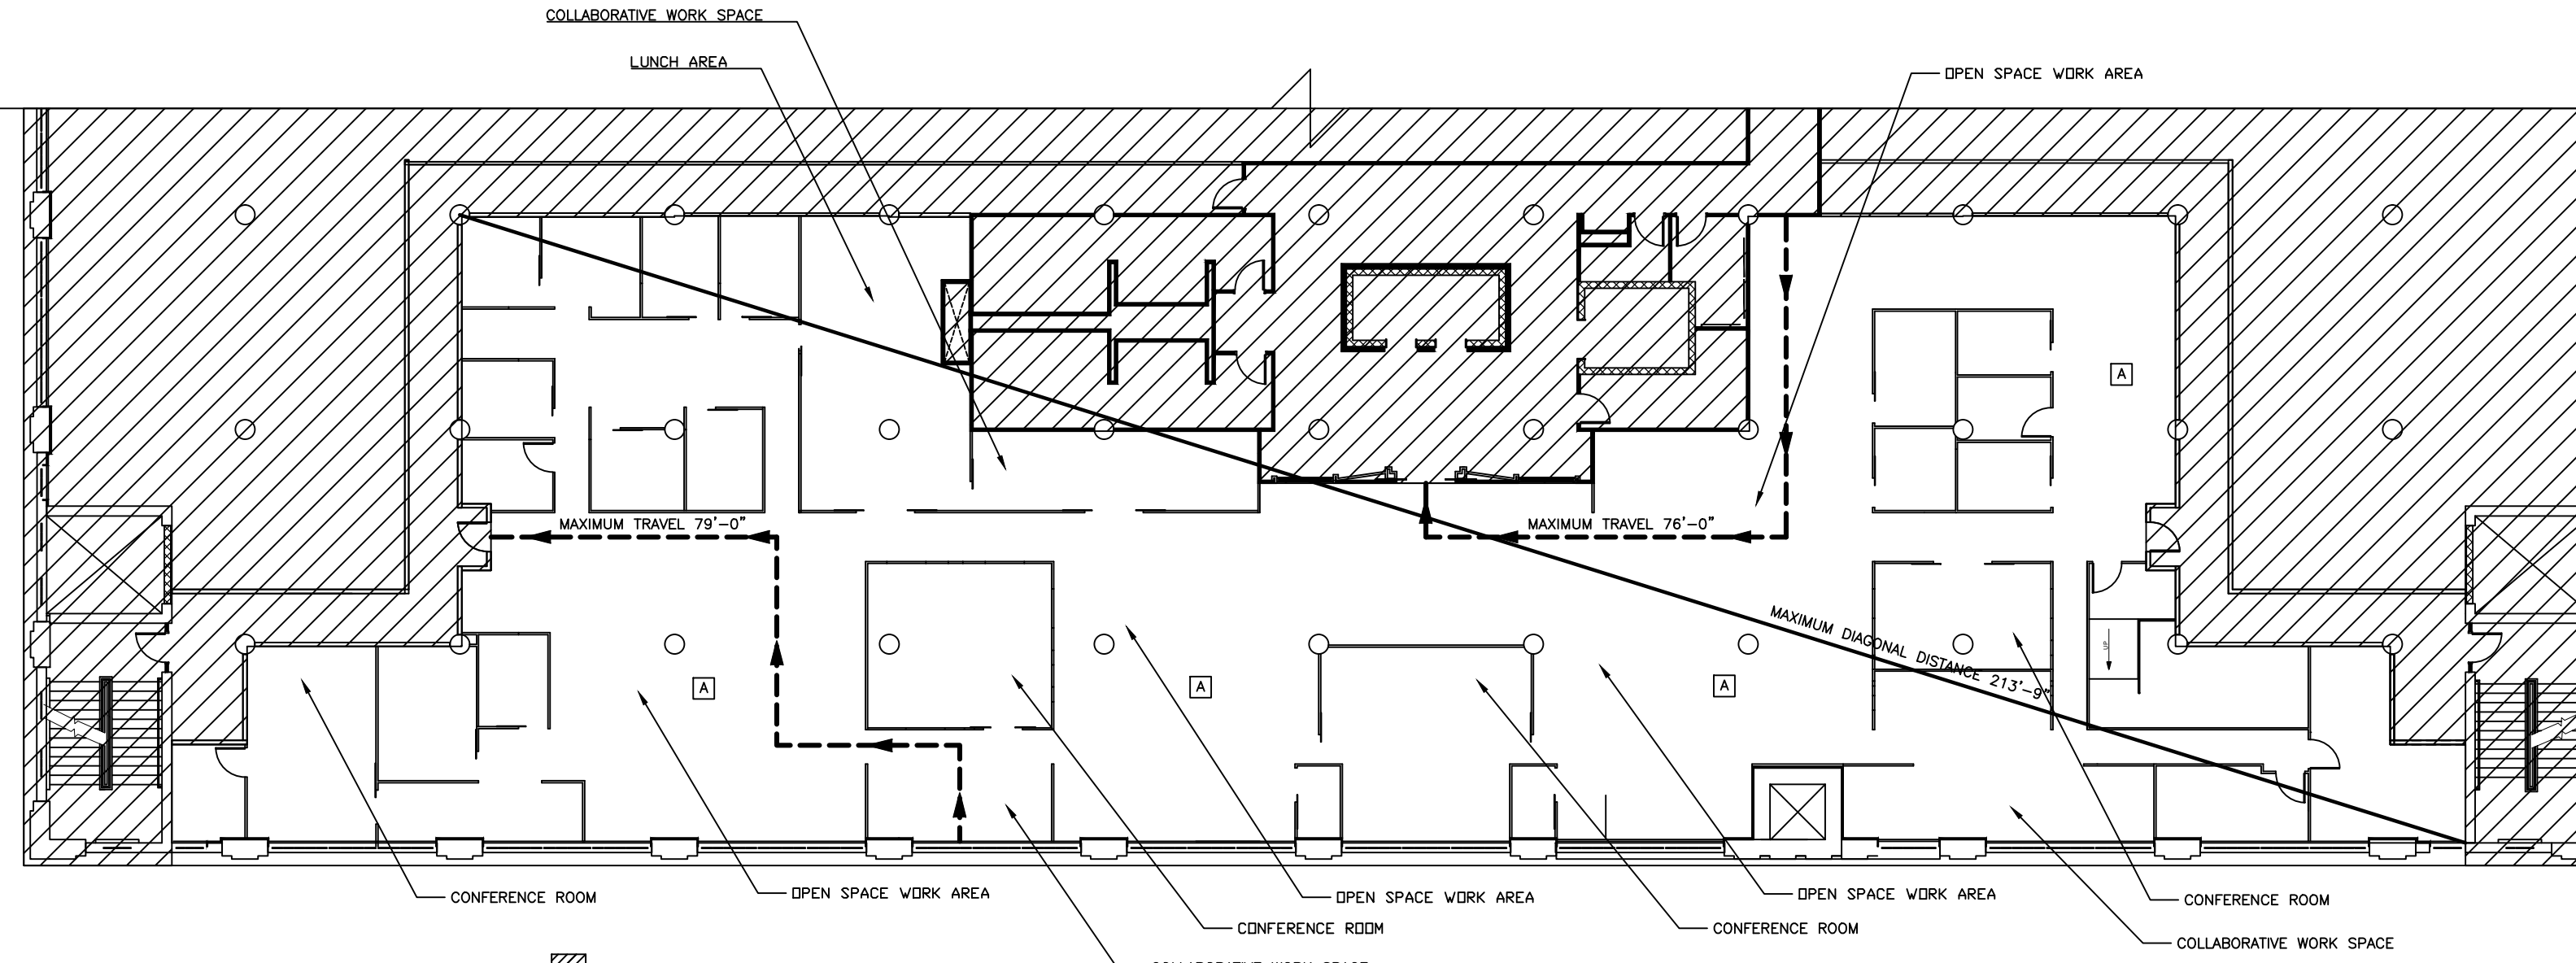
East – West Section

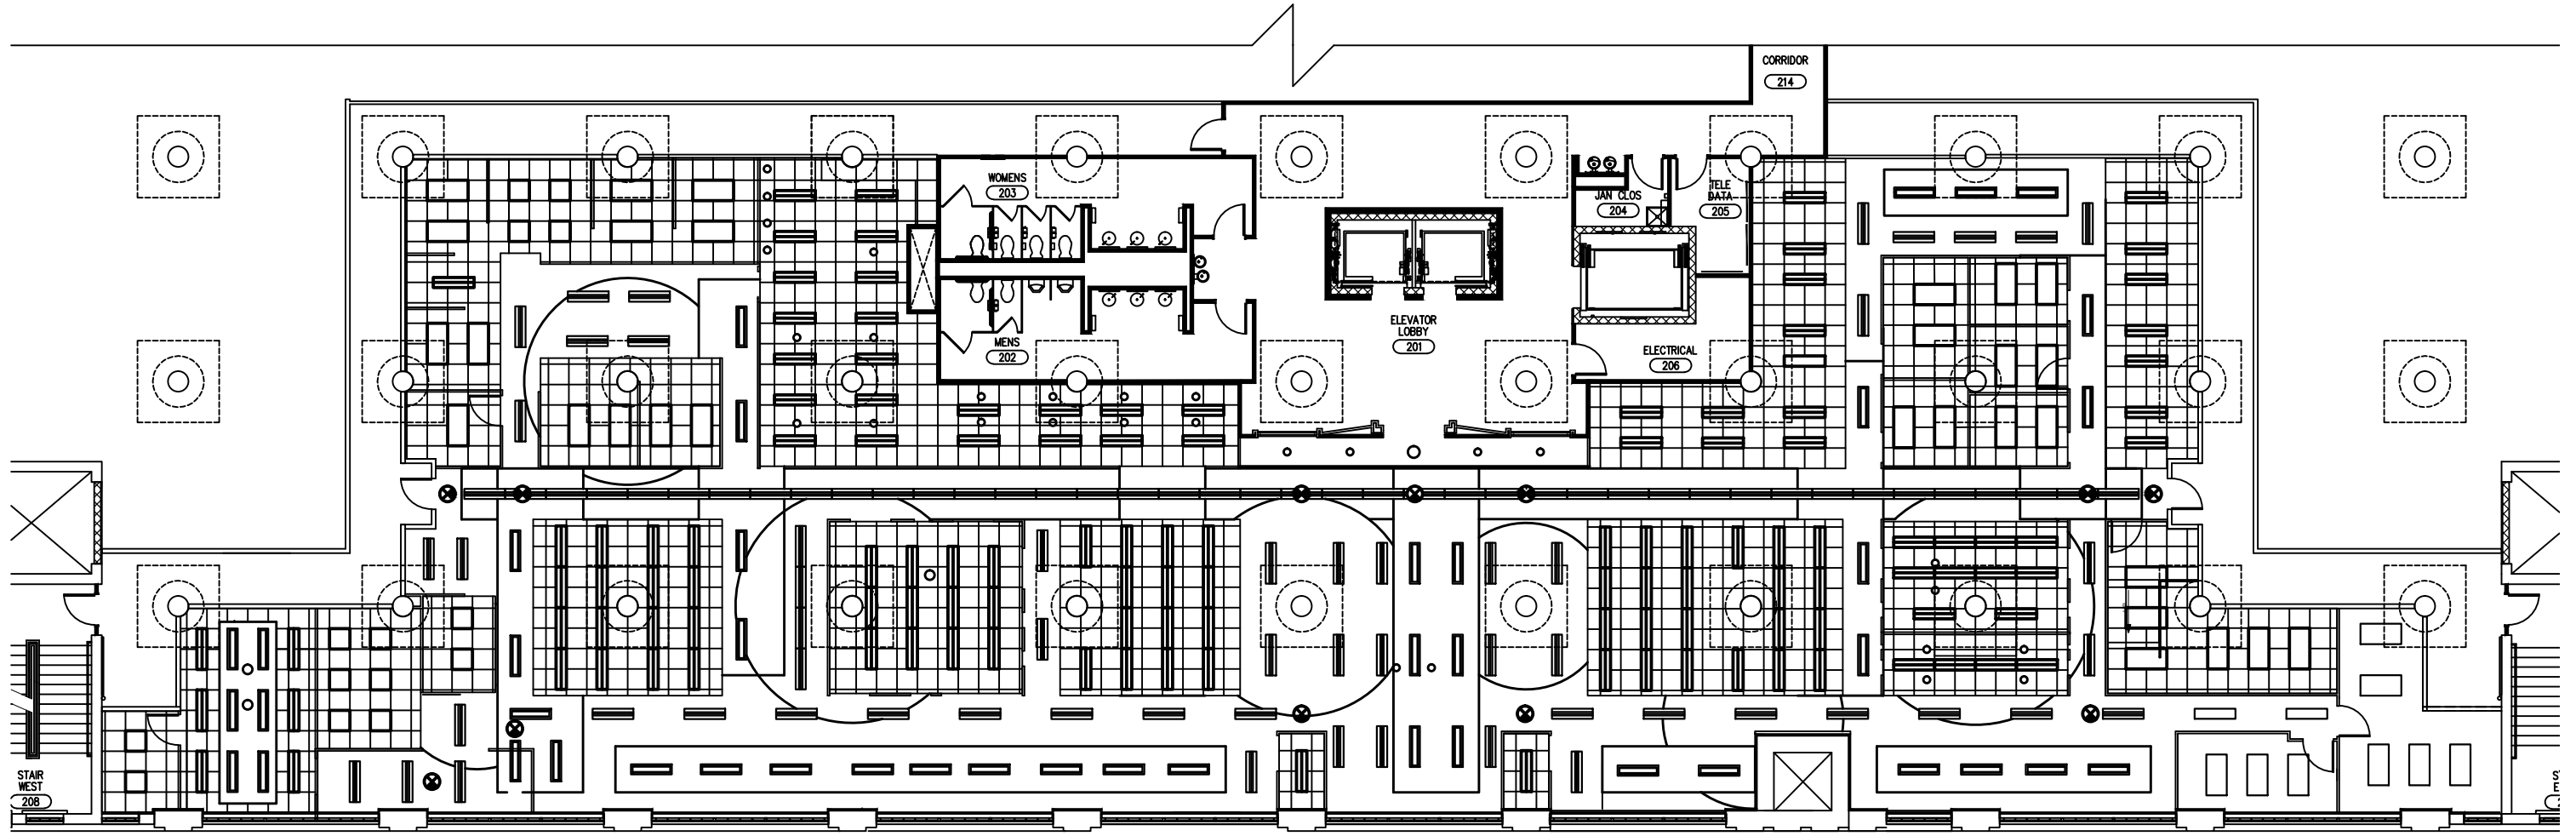



-  1 x 4 Inset Light Fixture
-  1 x 4 Pendant Light Fixture
-  Decorative Pendant Light Fixture
-  1 x 4 Drop In Light Fixture
-  2 x 2 Drop In Light Fixture
-  2 x 4 Drop In Light Fixture
-  Exit Sign

 **REFLECTED CEILING PLAN**
 Scale: 1/16" = 1'-0"



LIFE SAFETY PLAN
 Scale: 1/16" = 1'-0"

